




ELECTRICAL LEGEND					
	EXHAUST FAN & LIGHT KIT		CEILING FAN & LIGHT FIXTURE		PENDENT LIGHTING
	WALL LIGHT FIXTURE		CARBON MONOXIDE DETECTOR		LIGHT STRING
	CHANDELIER LIGHT FIXTURE		SMOKE DETECTOR		FLOOD LIGHTS
	RECESSED LIGHTING		WALL OUTLET		GFI WALL OUTLET
	CEILING MOUNTED LIGHT FIXTURE		LIGHT SWITCH		

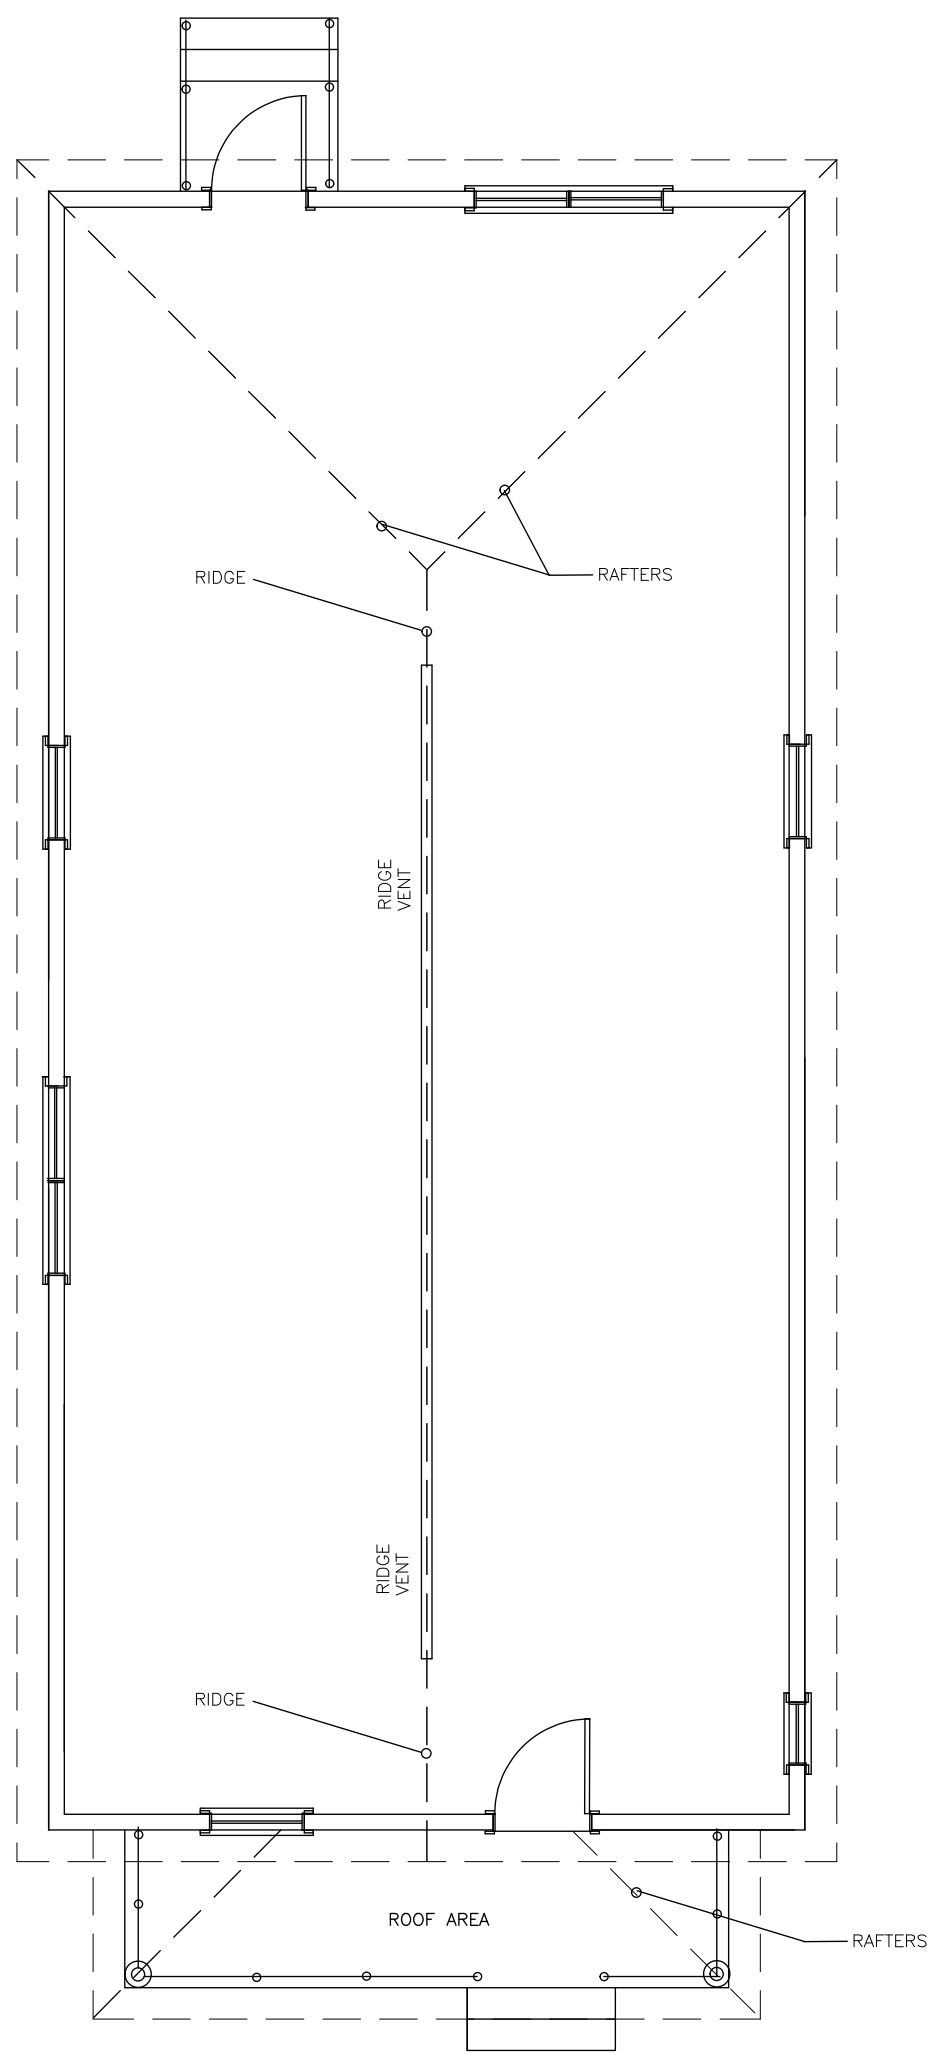

ROOF PLAN SCALE 1/4"

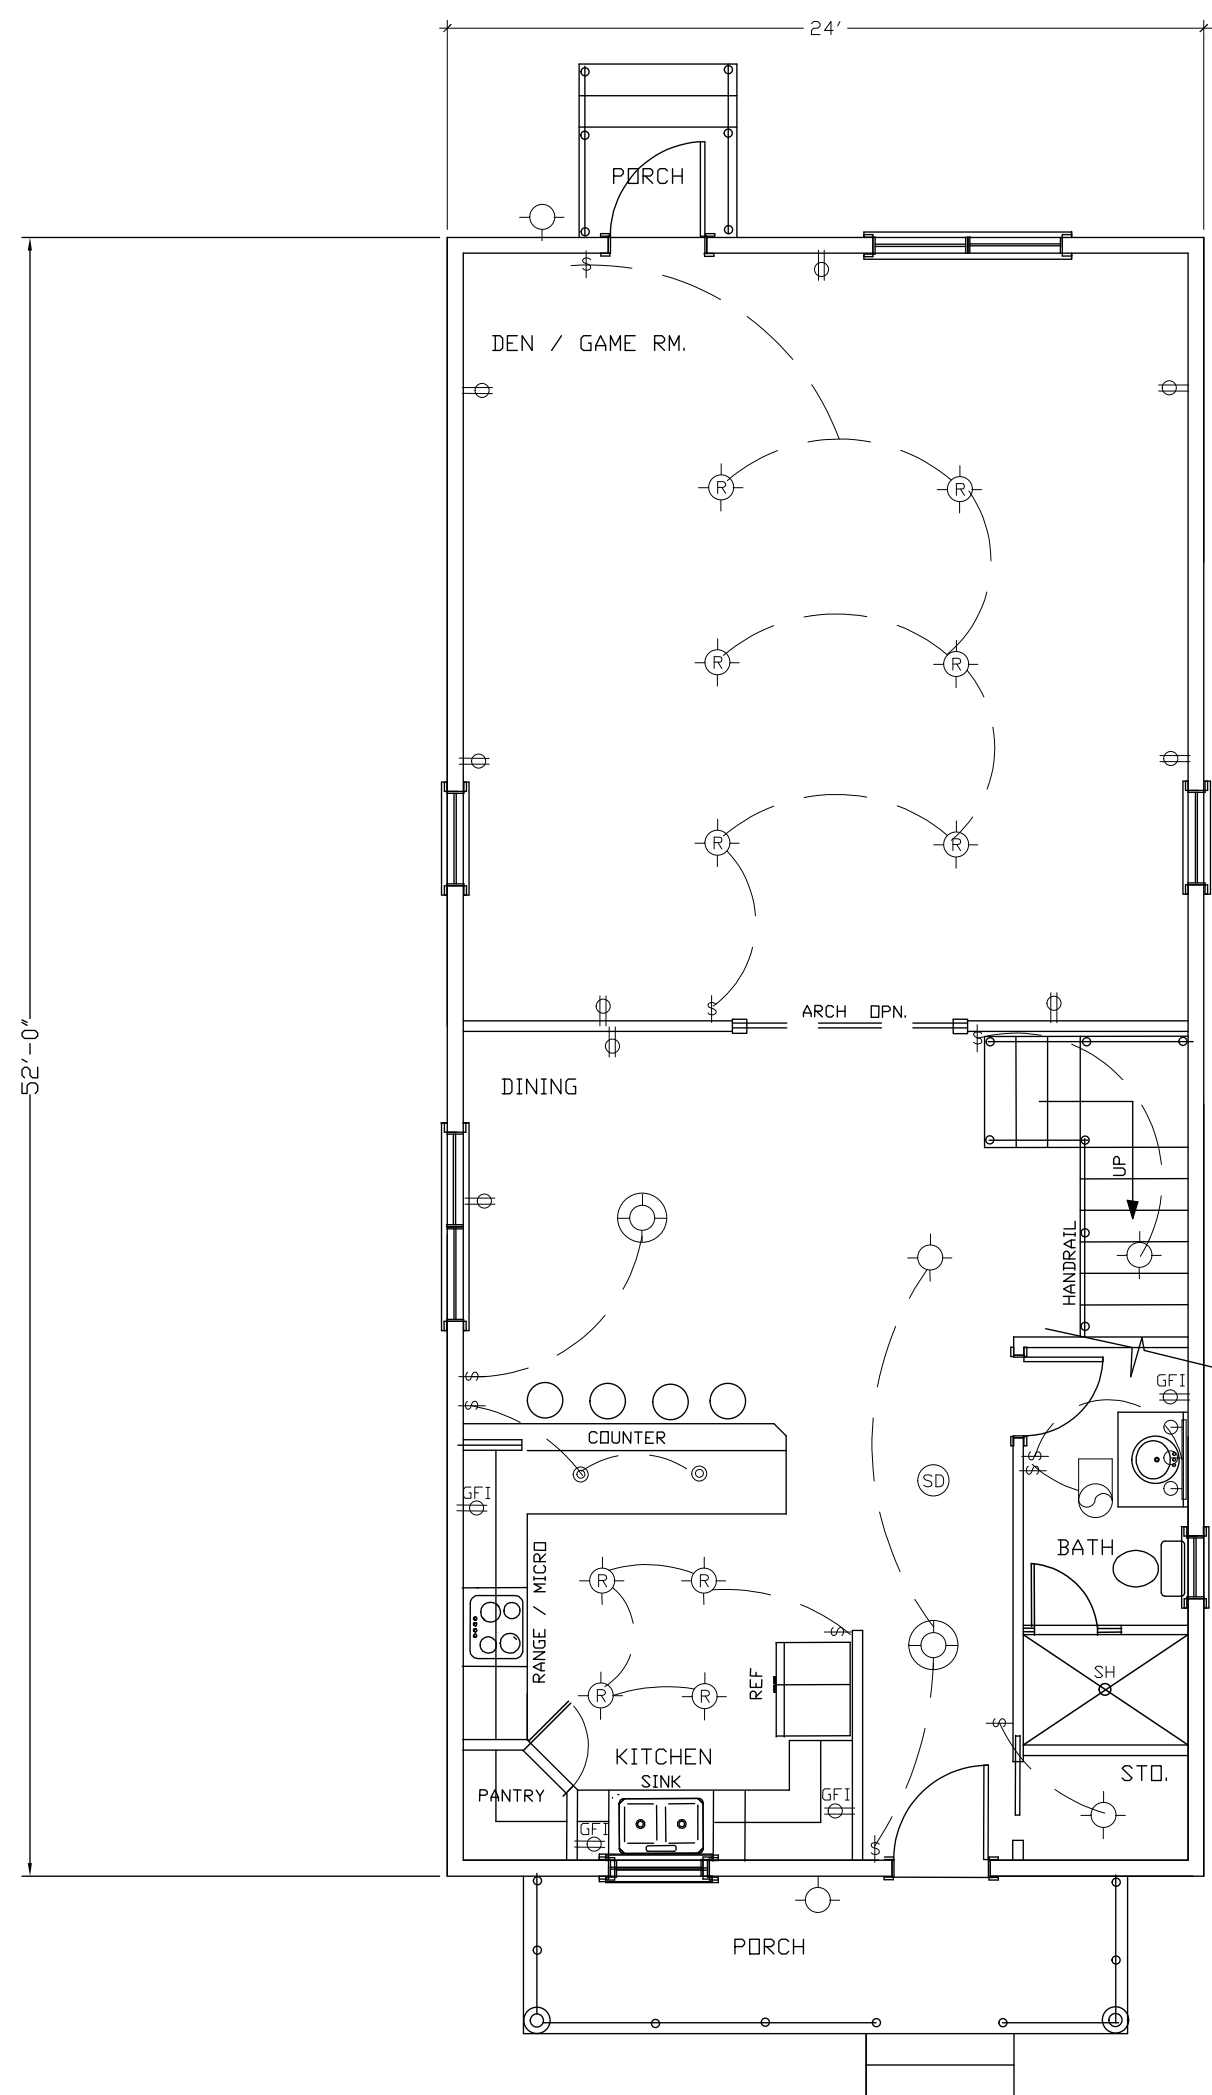

1 ST FLOOR PLAN SCALE 1/4"

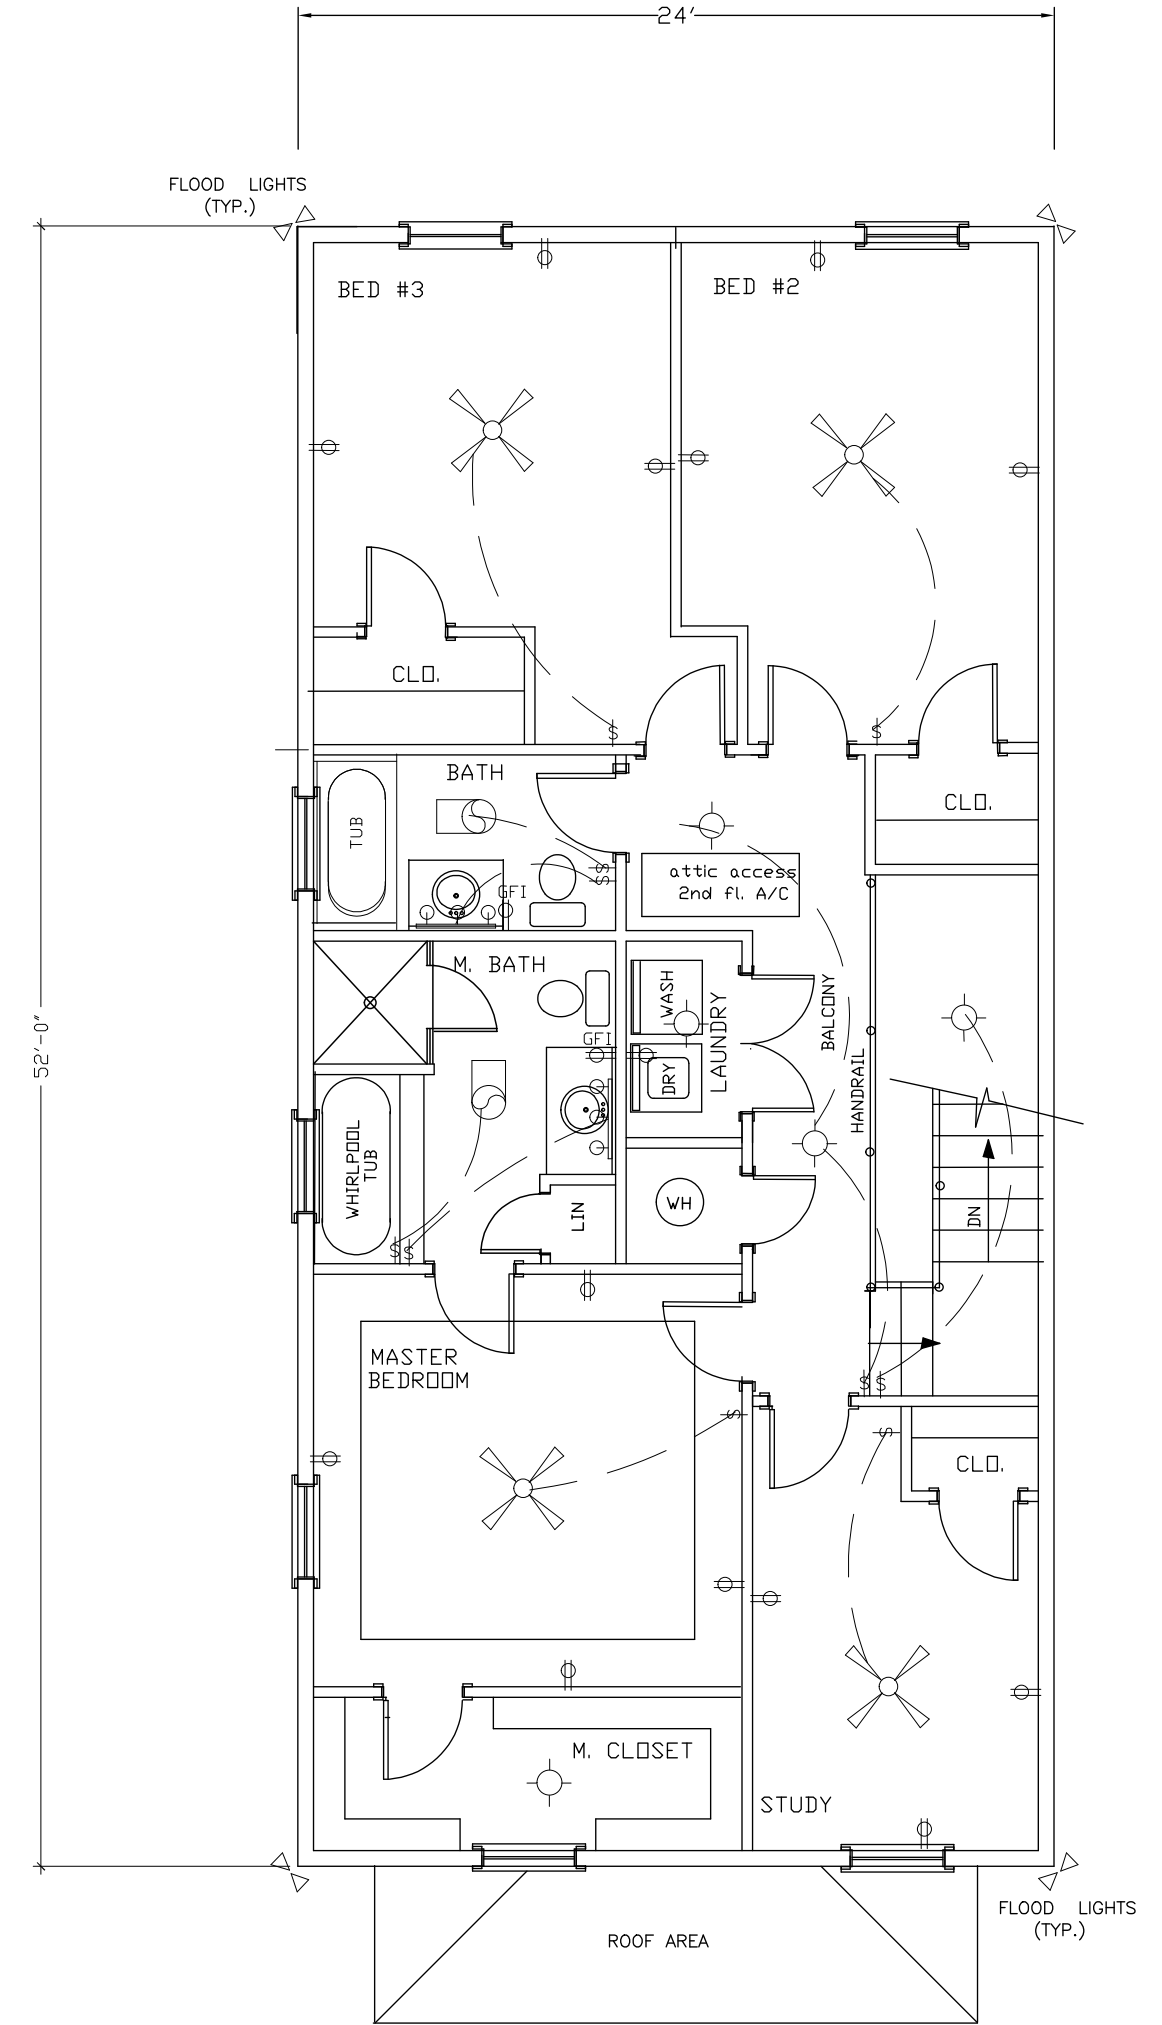

2ND FLOOR PLAN SCALE 1/4"

**THOMAS M. SMITH**  
CONSULTING ENGINEER  
6516 BOUTALL STREET  
METAIRIE, LOUISIANA 70003  
PH: (504) 247-6294  
**Design Drafting Services, LLC.**  
Lafayette, La. CELL: (512) 968-7770  
elbert@tmsm.com

**ELECTRICAL PLAN LAYOUT & LEGEND**  
**RENDELL ELLOE**  
2944 JEANETTE ST. NEW ORLEANS, LA.

DRAWN BY	ELBERT	DATE	04/21
CHECKED BY	T.S.	DATE	04/21
ENGR.		DATE	
DEPT.		DATE	
PROJECT		DATE	
CLIENT		DATE	
SCALE(S) SHOWN			

NO.	DATE	BY	DESCRIPTION	REVISIONS

JOB NO.	OWNER'S DWG NO.	DWG NO.	REV.
		A5	

Twp: 101230  
Date: 04/21/2021  
Drawing File: E:\PHS\PS\LAN2436  
C-200

NOTES

NOTES