


APPROVED  
maevans , 7/1/2022 , 12:16:18 PM

1  
- P-1

# 417 Tricou Street - Floor Plan

SCALE: 1/8" = 1'-0"

417 TRICOU STREET

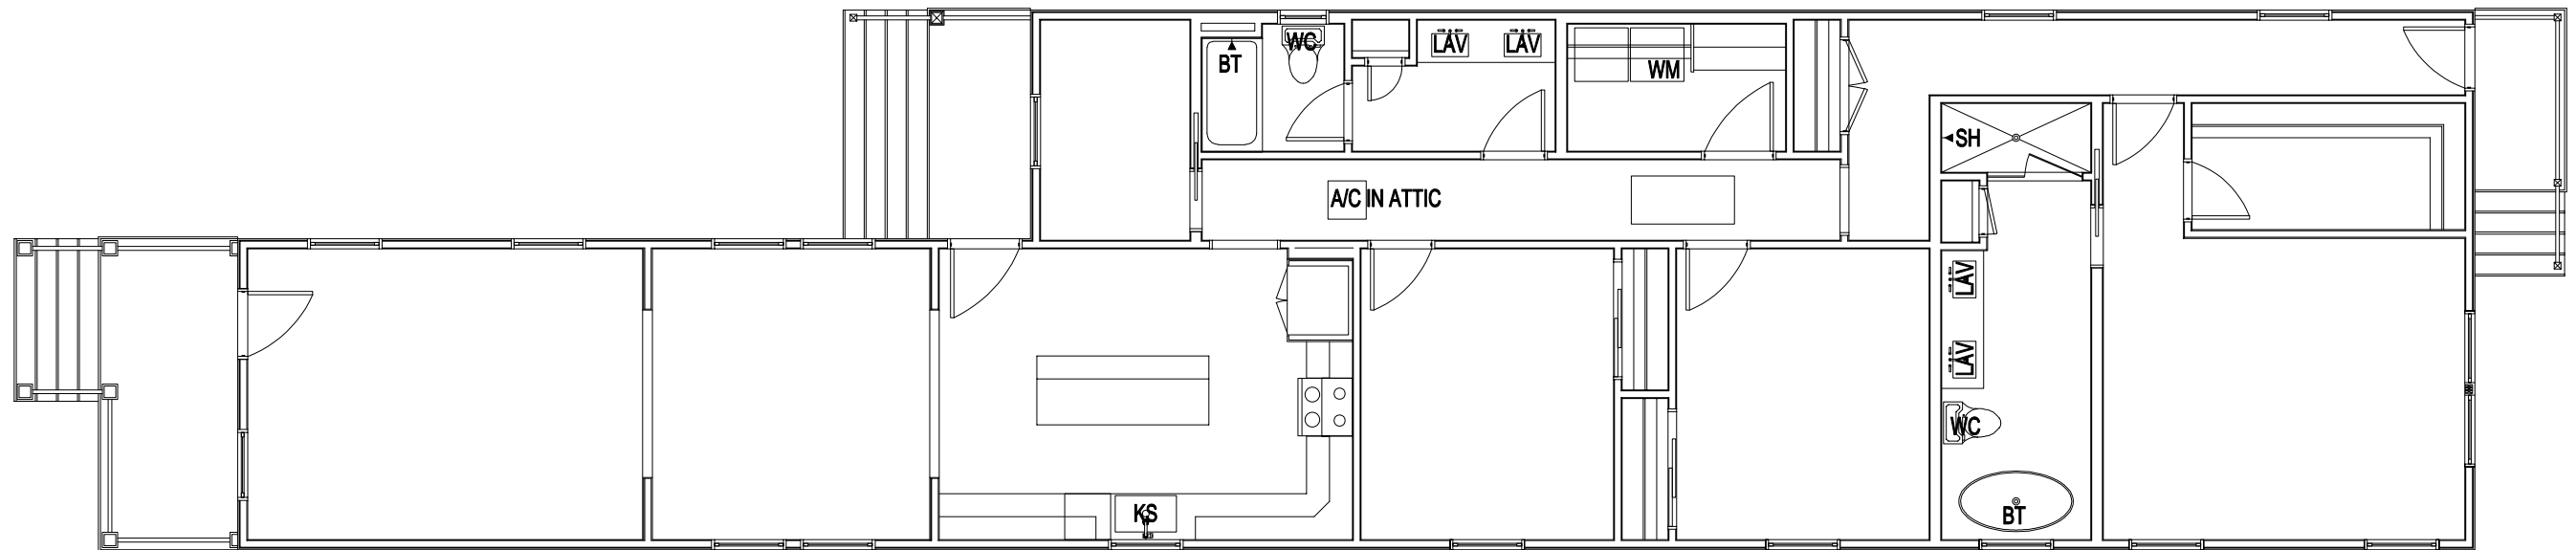

2 417 Tricou Street - Plumbing Riser Diagram  
- P-1

SCALE: 1/8" = 1'-0"