


APPROVED
maevans , 6/3/2022 , 12:42:15 PM

2 WATER AND VENT RISER-PLUMBING
P-2 SCALE: N.T.S.

1,277 GSF

1 FIRST FLOOR PLAN - PLUMBING
P-2 SCALE: 3/16" = 1' - 0"

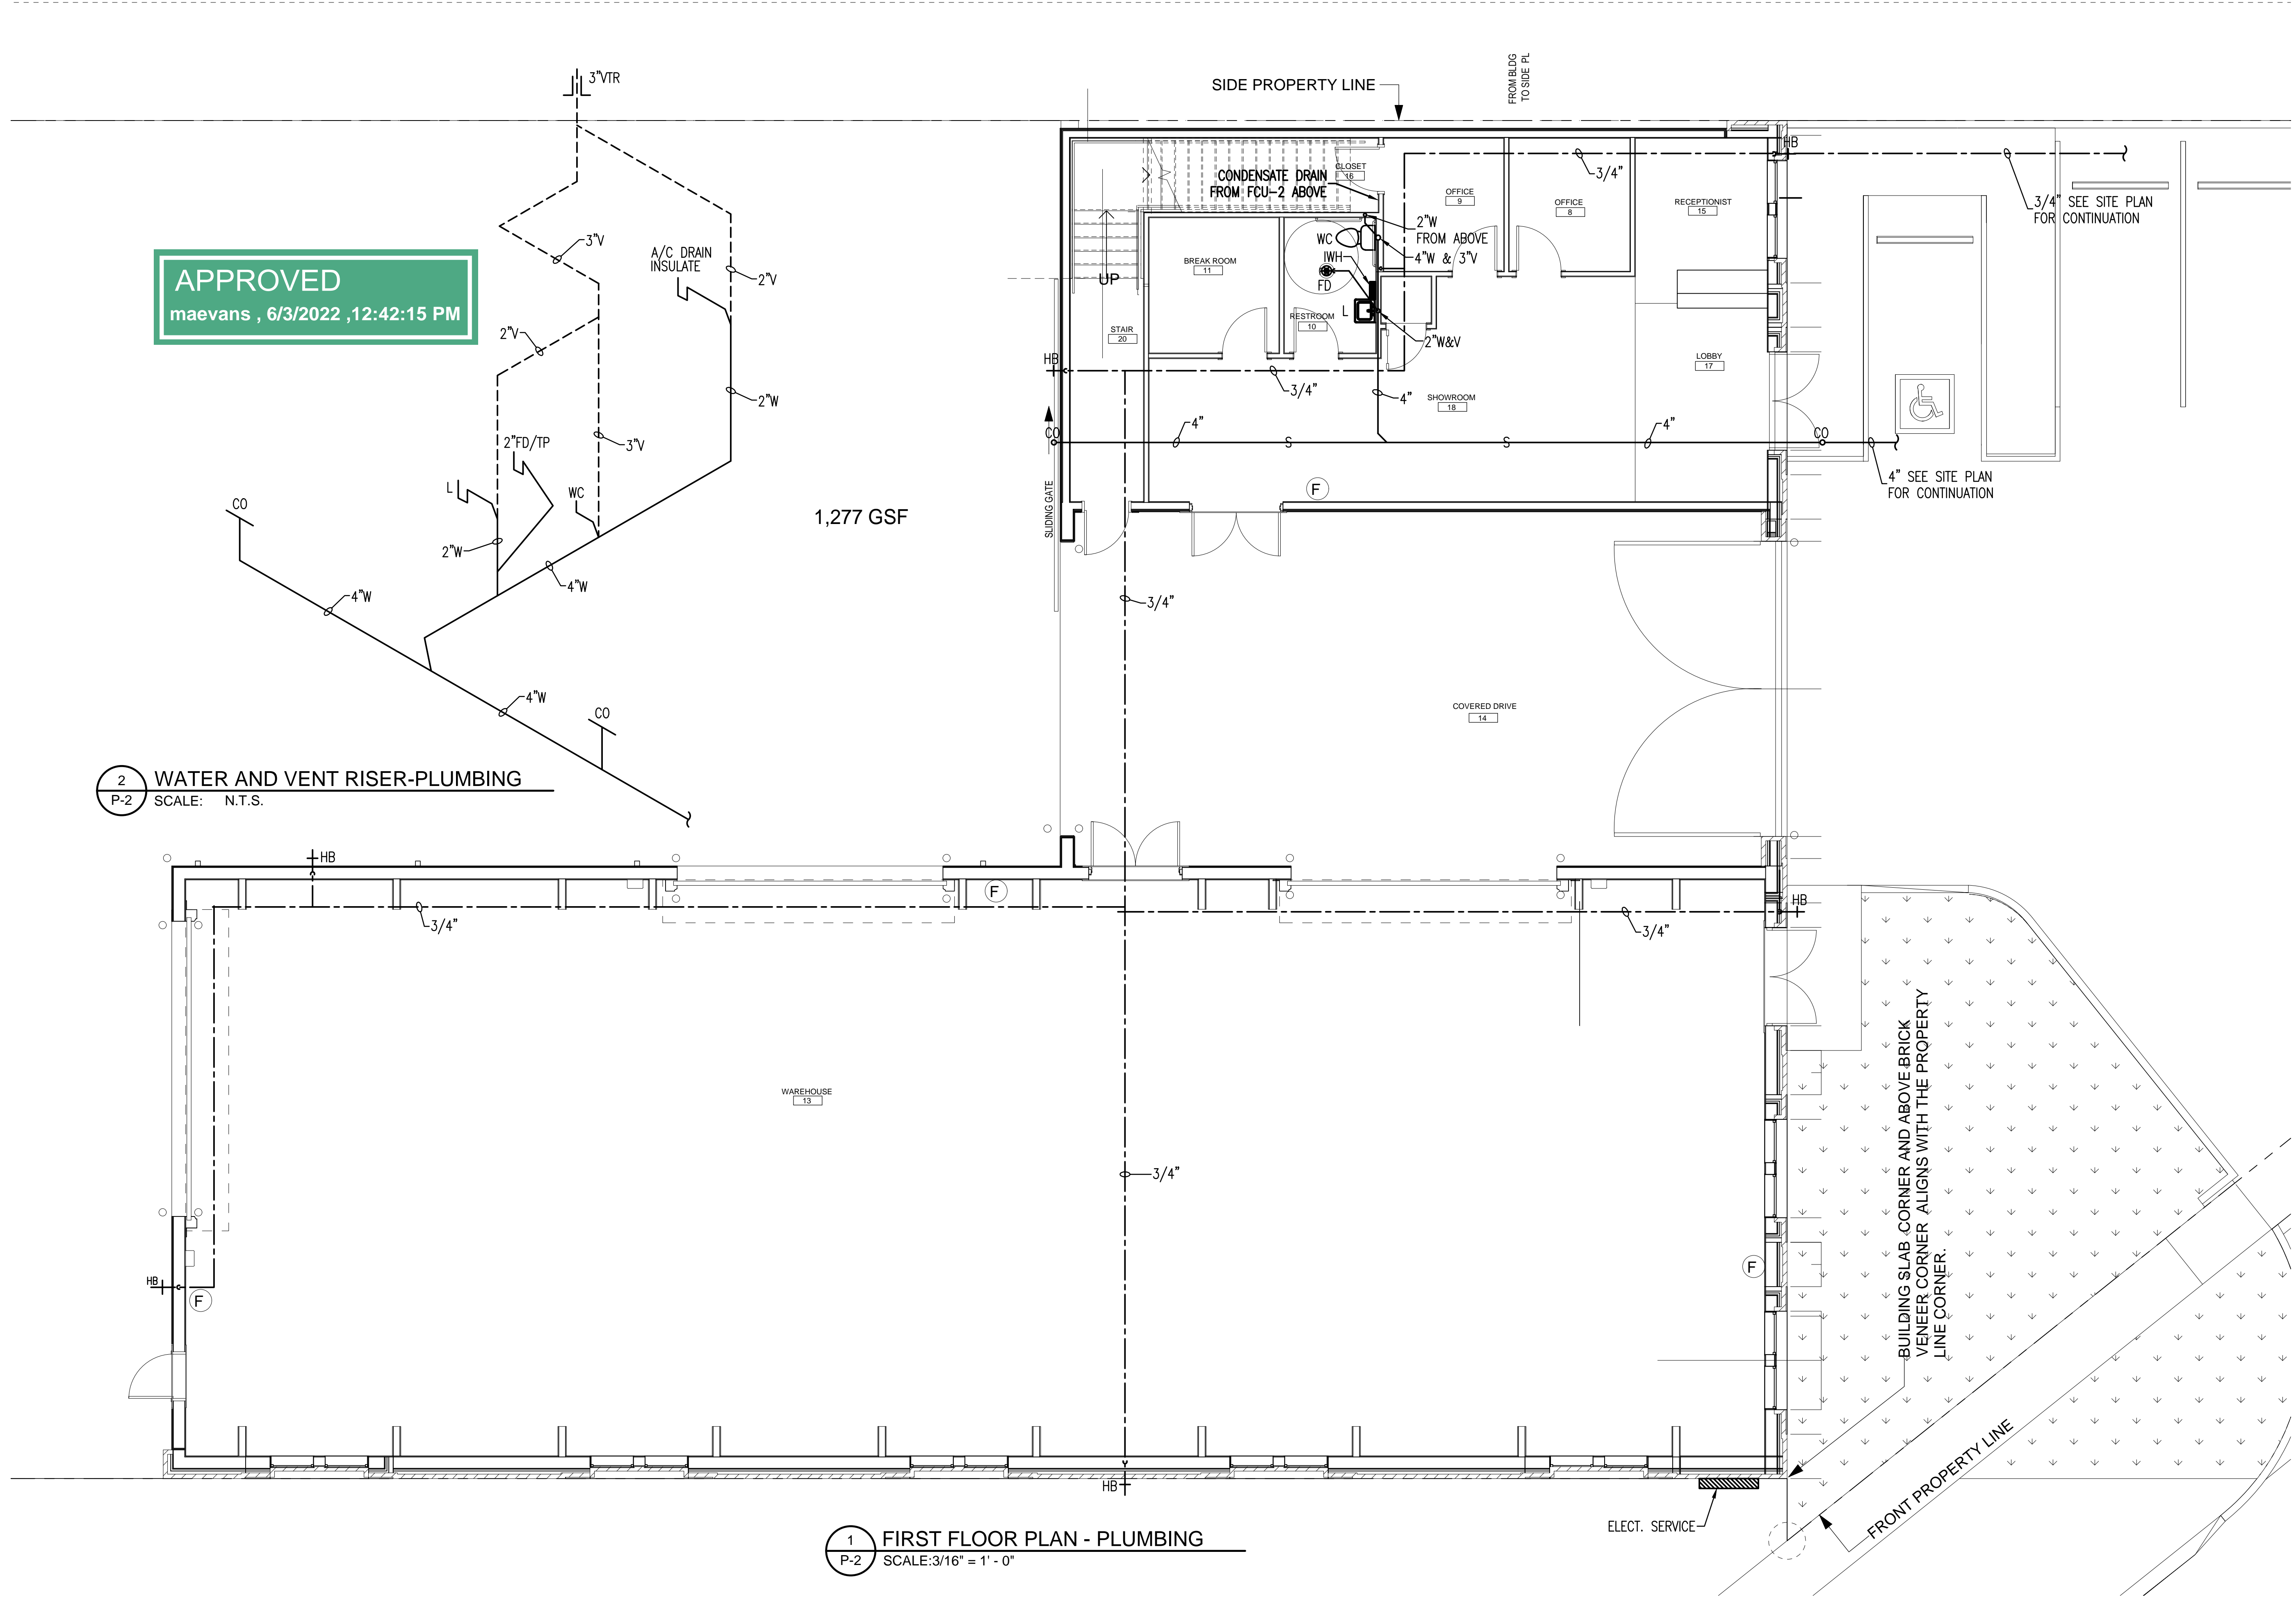


M-K ENGINEERING, INC.
CONSULTING ENGINEERS
HVAC-PLUMBING-FIRE PROTECTION-ELECTRICAL
4323 Division Street, Suite 211
Metairie, LA 70002
Tel: (504) 887-2376, Fax: (504) 887-2302
Email: mkansagra@m-k-e.com
M-K Project No.: 22-015

Permit Set	04.15.22
Progress Set	02.15.22

NO	REVISION	DATE
CRESCENT CITY FOREST PRODUCTS	PROJECT	
9000 PALMETTO STREET NEW ORLEANS, LA 70118		
22010	JOB NO	

FLOOR PLAN - PLUMBING	TITLE
AS SHOWN	SCALE
DD / MK, NH	Author / Checker

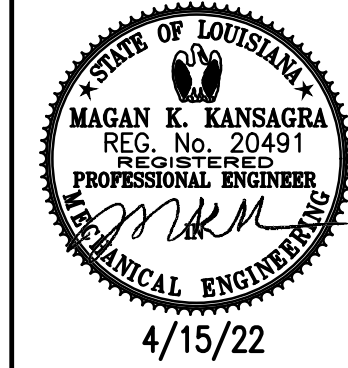

P2.0

RW ROZAS WARD
architects
A PROFESSIONAL CORPORATION www.rozas-ward.com
1100 POYDRAS ST. SUITE 3550 NO LA 70163 504-524-4375