

TREME HOUSE 1

810 N. Roman
New Orleans, LA, 70116

marais

marais architects llc

ARCHITECT:
MARAIS ARCHITECTS, LLC
jared@maraisdesignbuild.com



Revision Schedule		
Revision Number	Revision Description	Revision Date
2	ISSUE FOR PERMIT	22.06.28


ISSUANCE:

SHEET TITLE: **Plumbing Riser Diagram**
SHEET NUMBER: **A4.1**


DATE: FOR PERMIT

SCALE: As indicated


APPROVED
maevans , 7/21/2022 ,12:13:06 PM

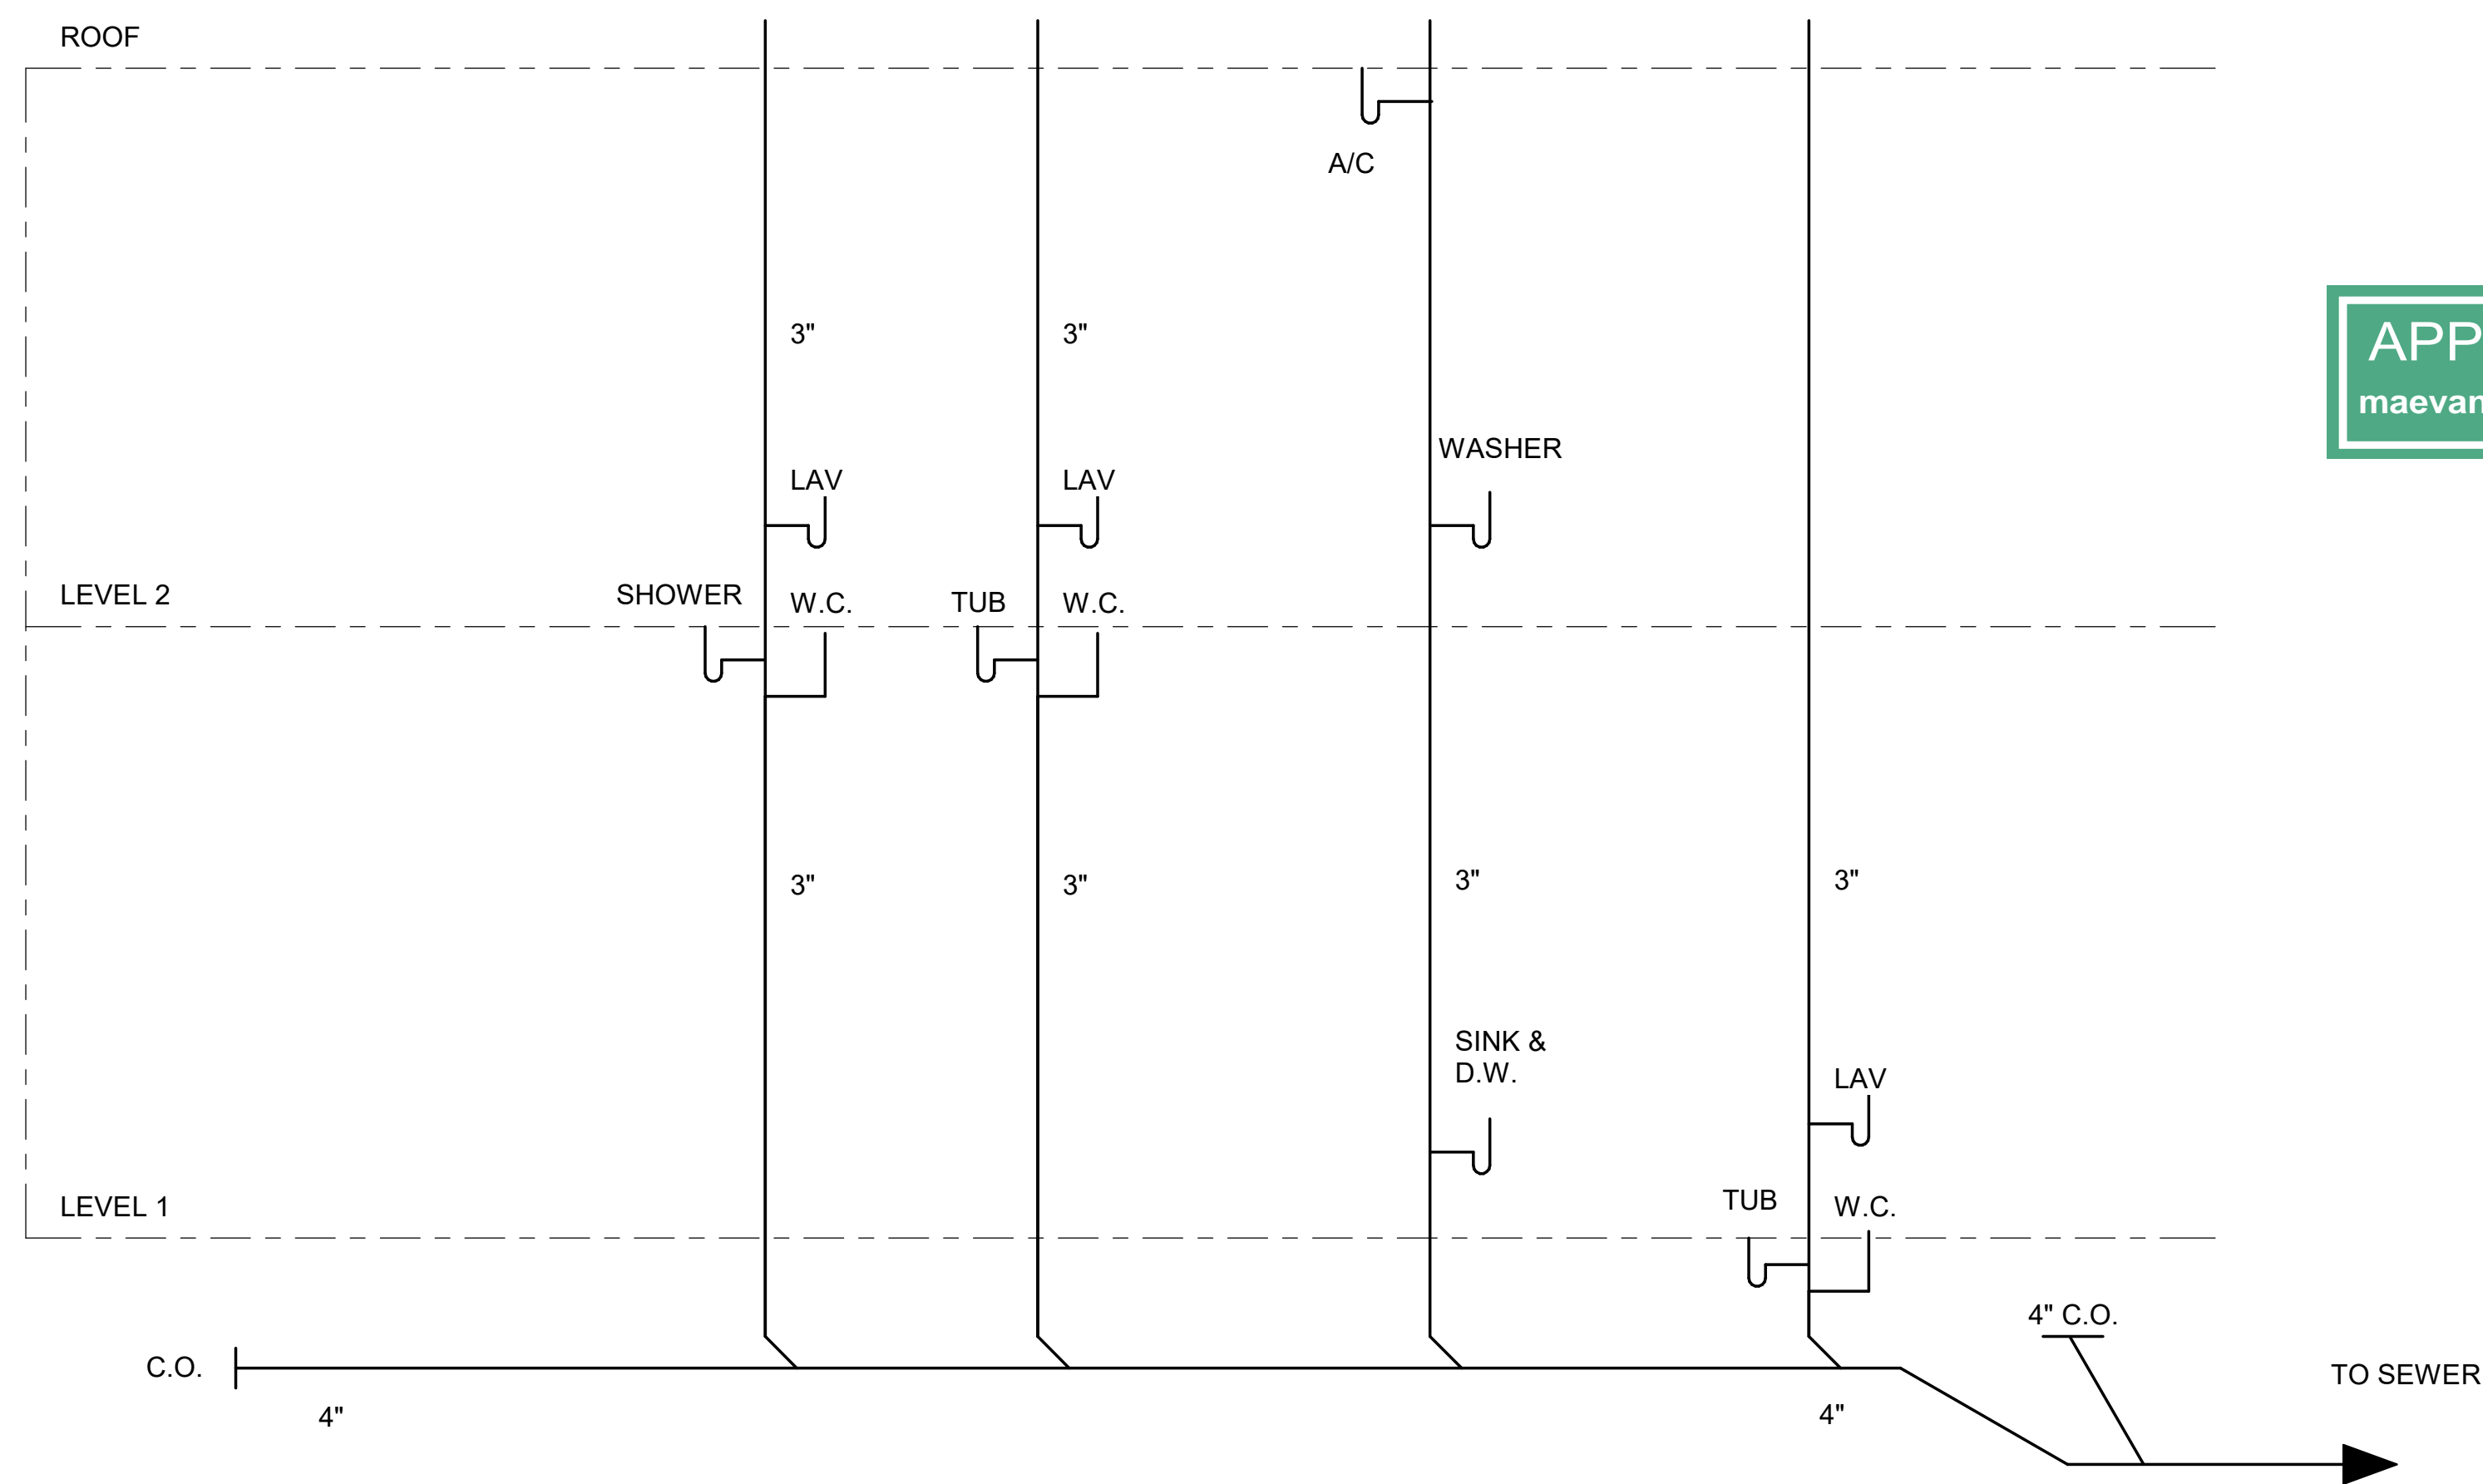

1 Plumbing Riser Diagram
1/2" = 1'-0"

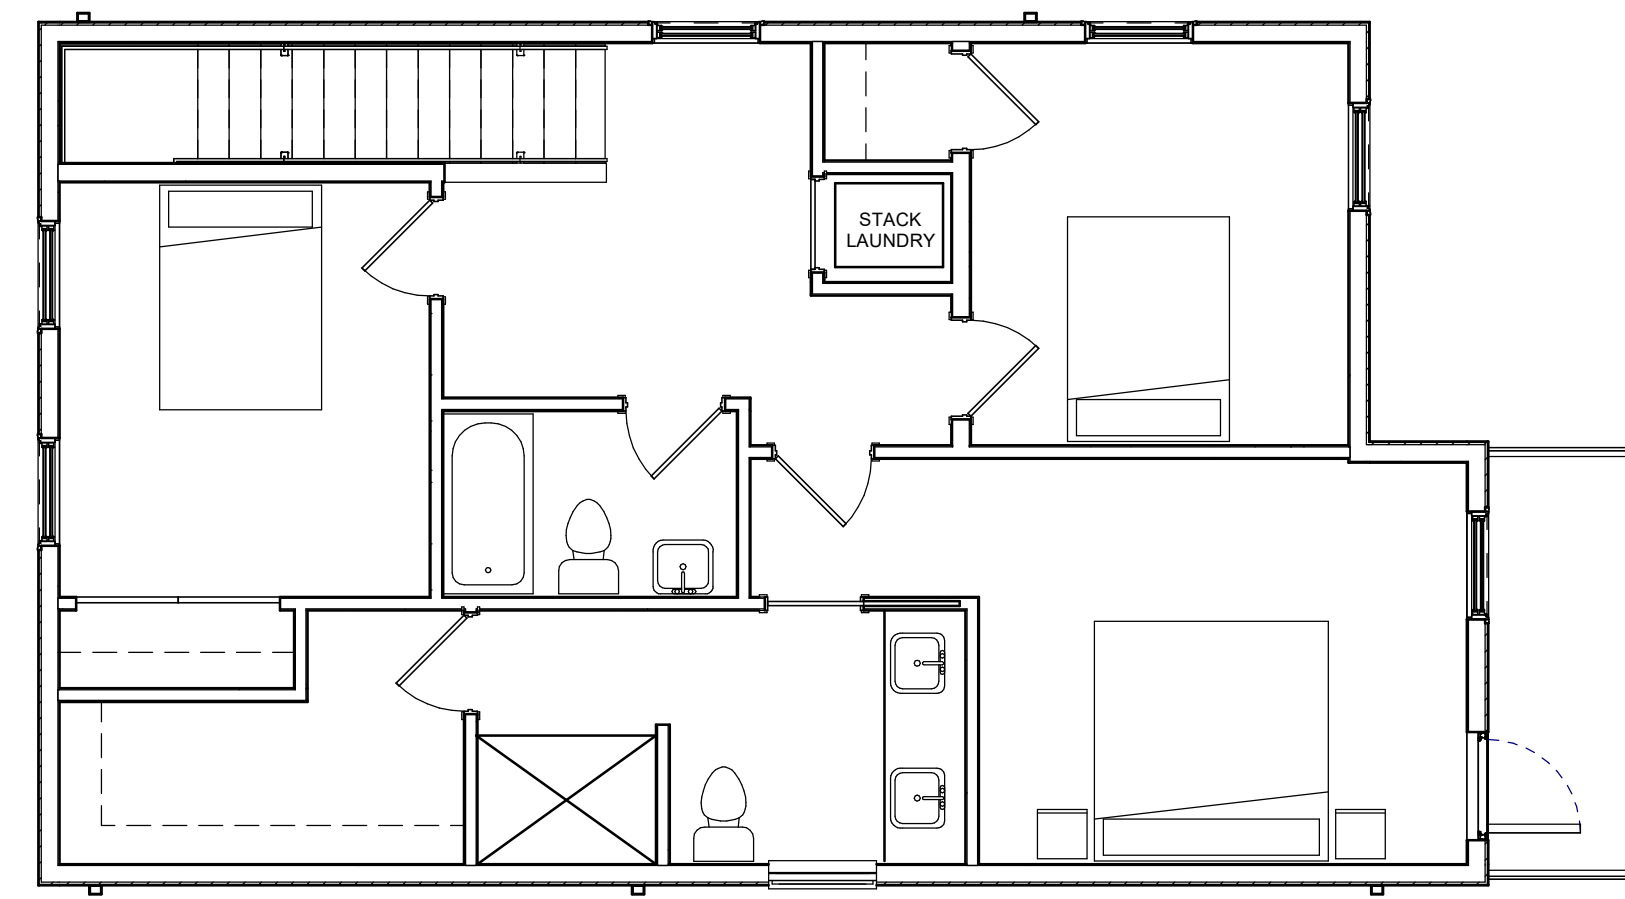

3 Level 2
3/16" = 1'-0"

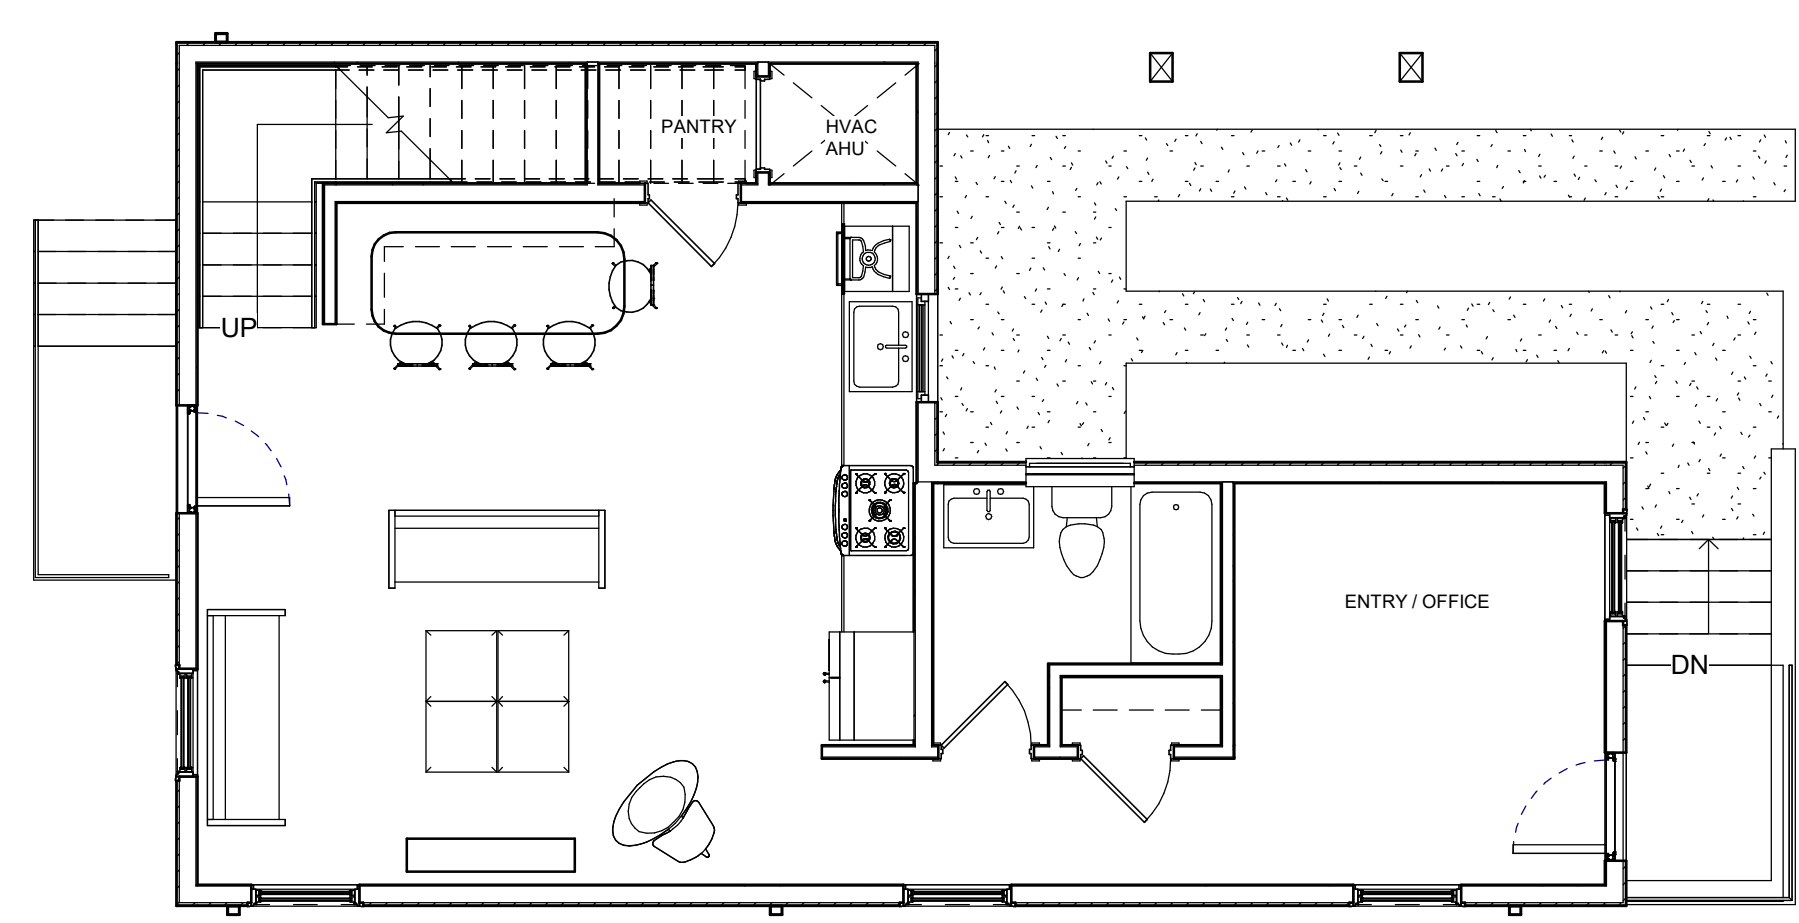

2 Level 1
3/16" = 1'-0"