


Revision Schedule		
Revision Number	Revision Description	Revision Date
2	ISSUE FOR PERMIT	22.06.28

ISSUANCE:

SHEET TITLE:
**Plumbing
 Riser**
 SHEET NUMBER:
A4.1


DATE: FOR PERMIT

SCALE: As indicated

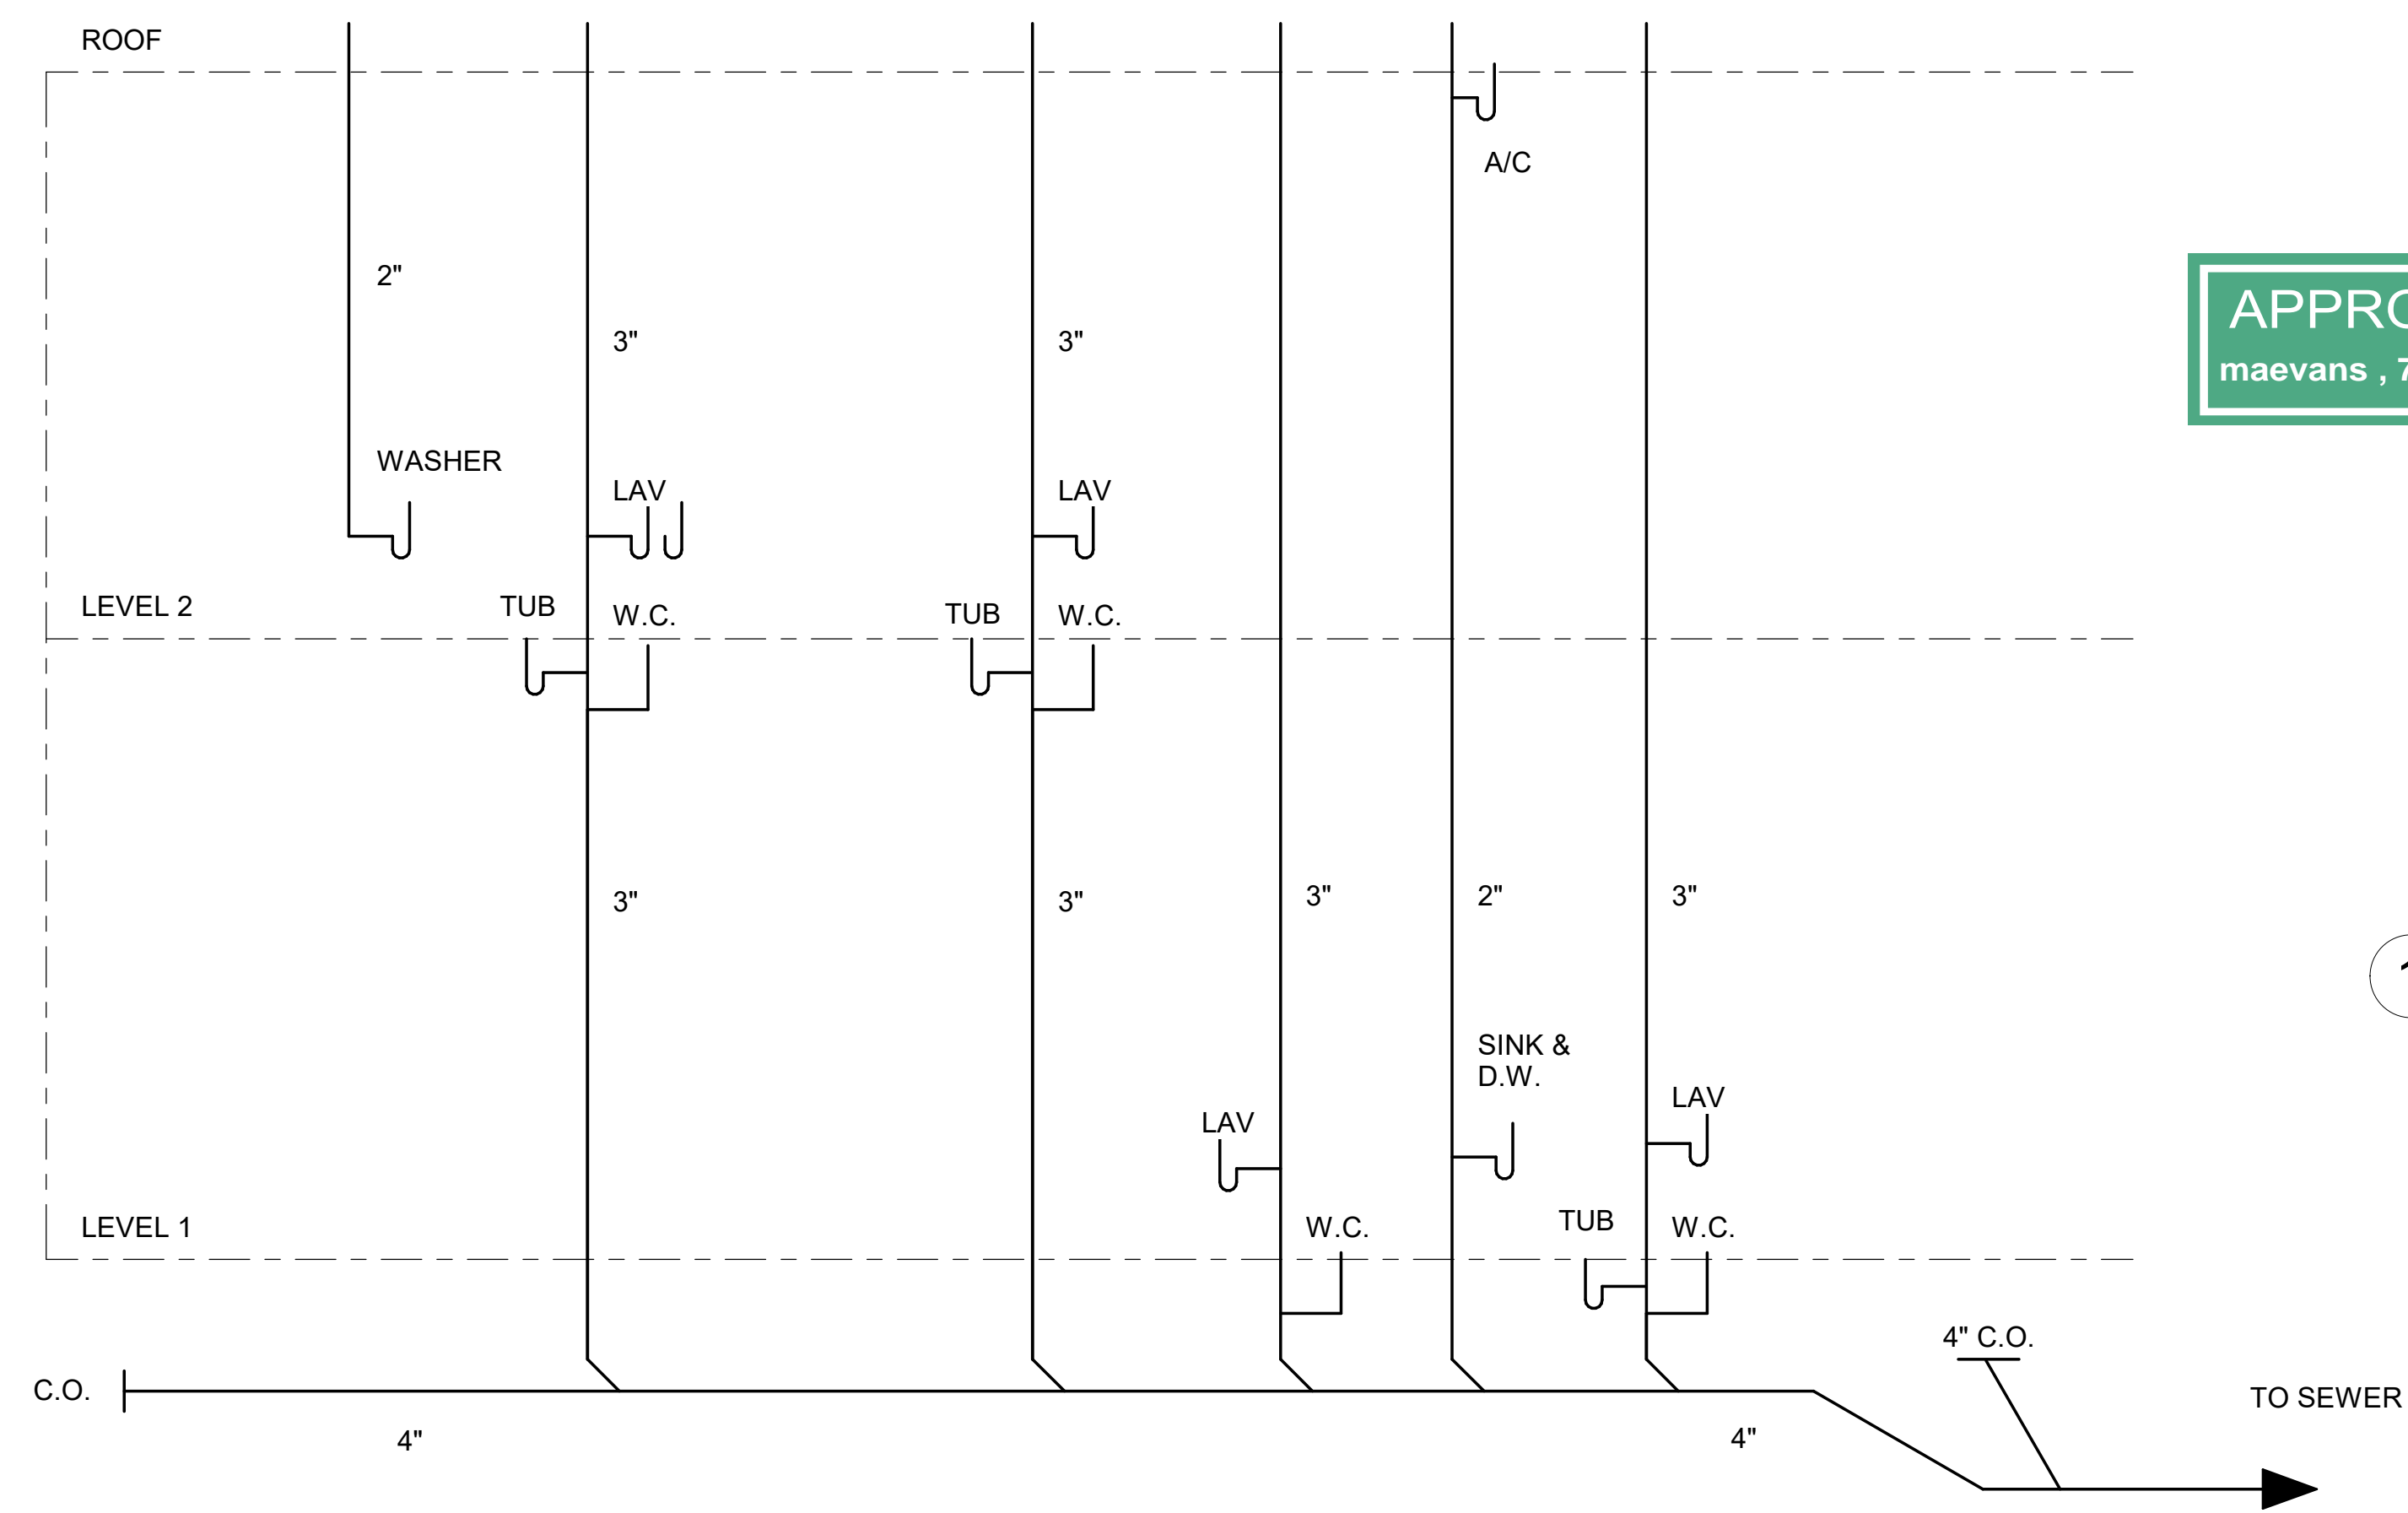


APPROVED
 maevans , 7/15/2022 , 12:51:28 PM

1 Plumbing Riser Diagram
 1/2" = 1'-0"

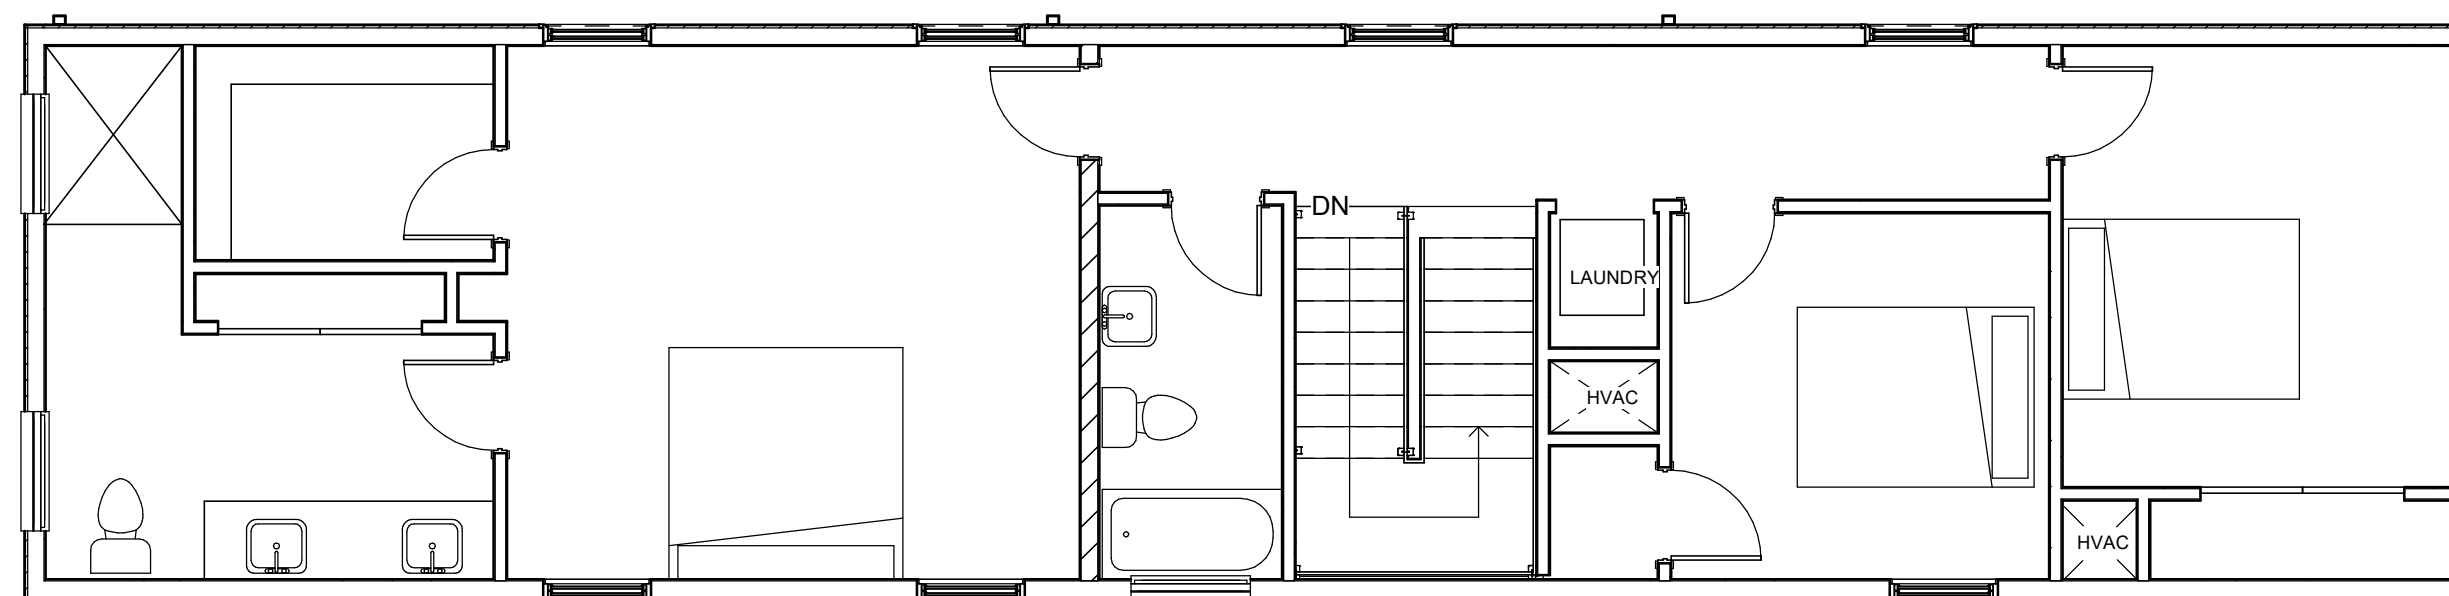

3 Floor Plan - Level 2
 3/16" = 1'-0"

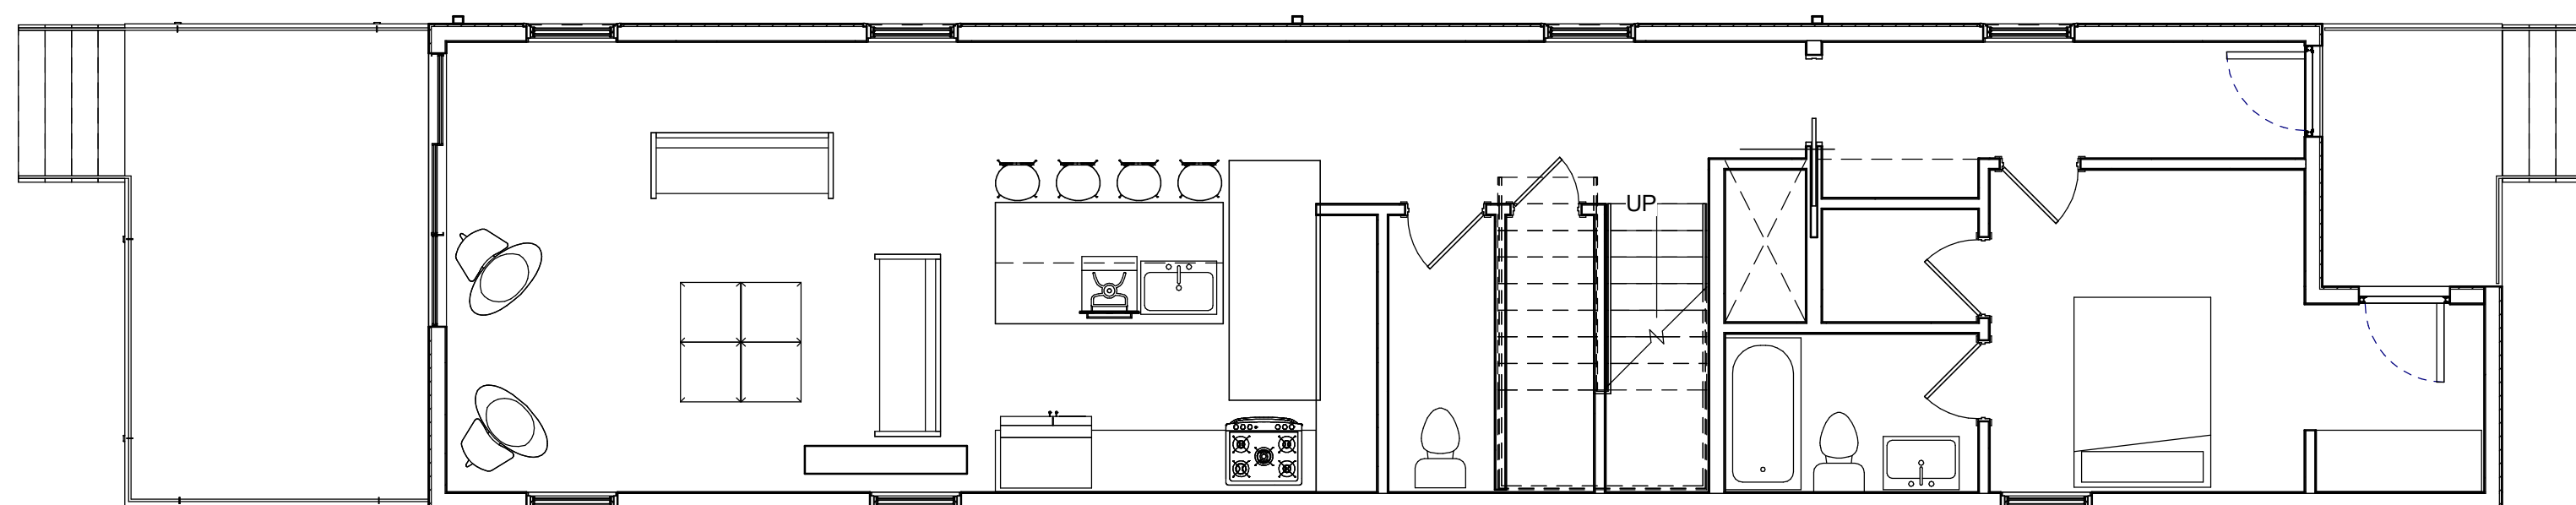

2 Floor Plan - Level 1
 3/16" = 1'-0"