


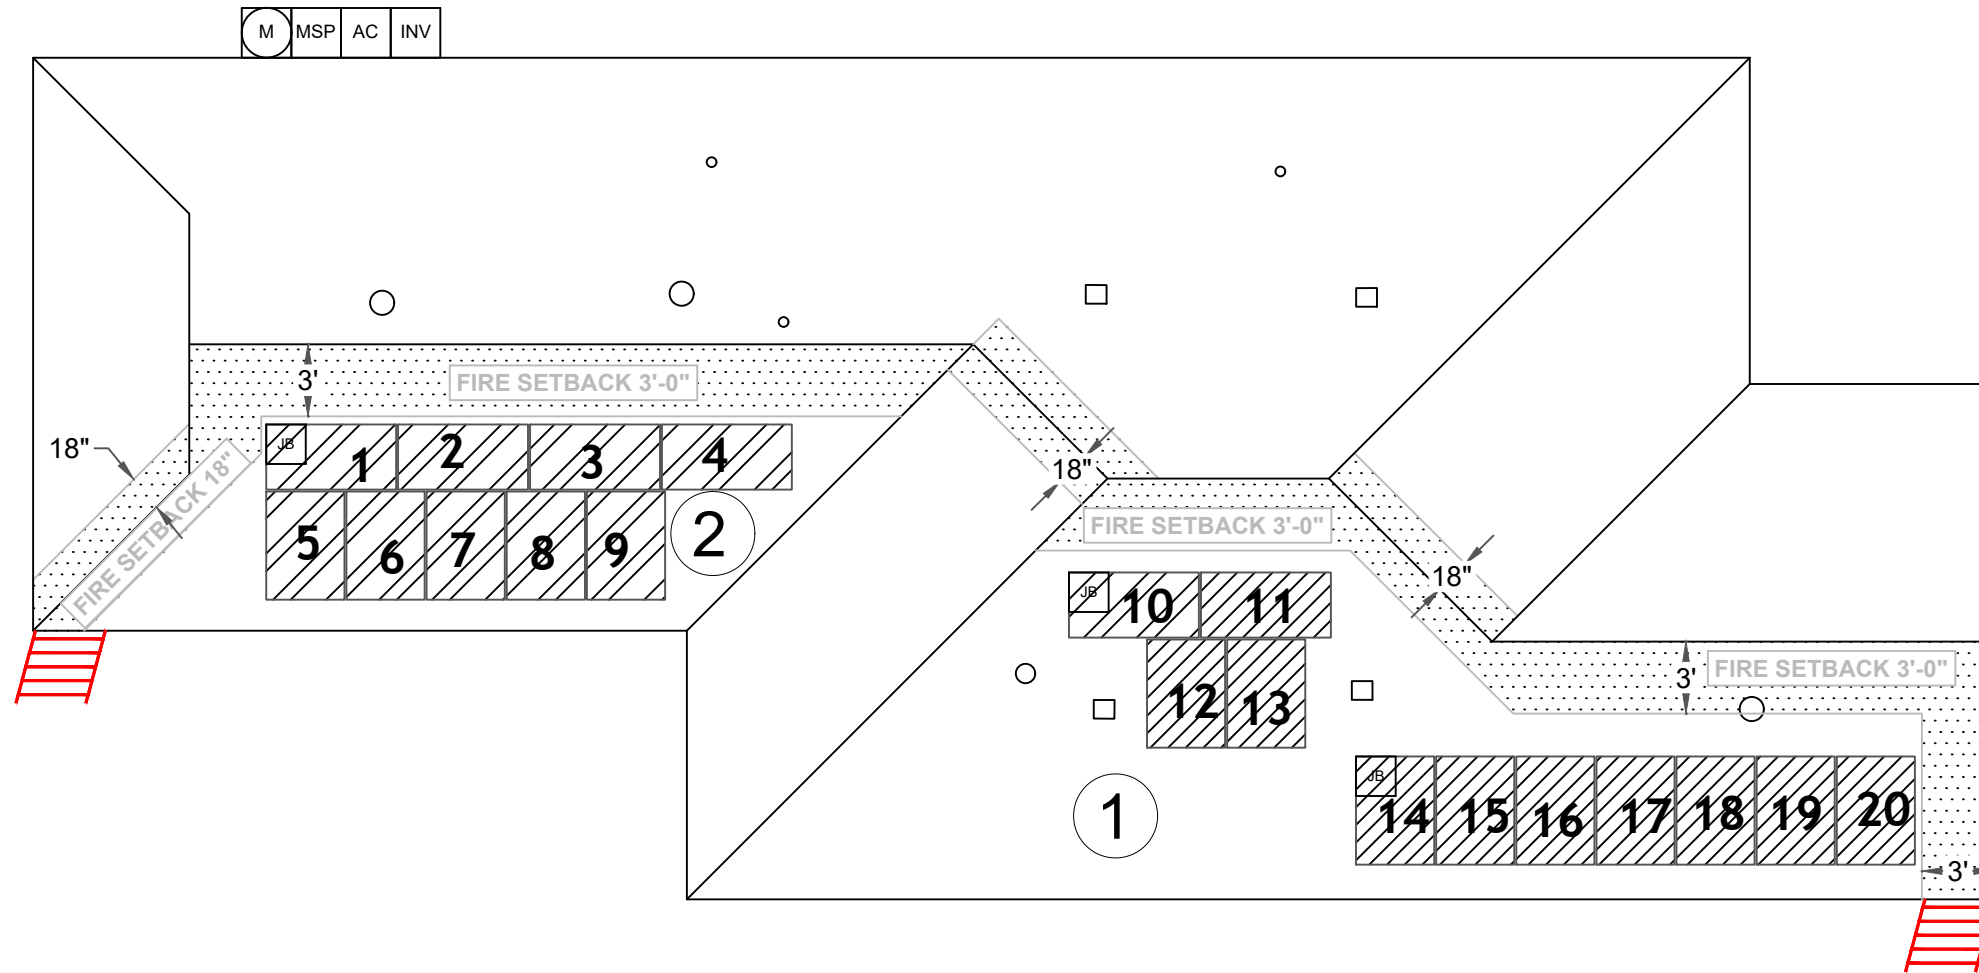

**LAYOUT IS APPROVED
BY THE CUSTOMER**

VERMILLION BOULEVARD



P-003227

GG17945

**6045 VERMILLION
BLVD
NEW ORLEANS, LA
70112**

FIRE CODE OFFSET

GROUND ACCESS POINT

**CNO
OPP # 199656**

STRING'S

STRING #1 - 10 MODULES

STRING #2 - 10 MODULES

ROOF SECTION(S):

①	SLOPE:	34
	MODULE:	11
	AZIMUTH:	176
②	SLOPE:	34
	MODULE:	9
	AZIMUTH:	176

**REDEPLOY
5.60 SE TALESUN 280
SYSTEM # S-012133**

PosiGen
Solar • Energy Efficiency • Roofing

POSIGEN DEVELOPER, LLC
819 Central Ave, Suite 210
New Orleans, LA 70121

JOB NUMBER: 199656
UTILITY: ENTERGY NEW ORLEANS
RACKING: K2 CROSS RAIL SYSTEM
MODULES: (20) TALESUN SOLAR TP660M-280W
OPTIMIZER: (20) SOLAREEDGE OPTIMIZER P300
INVERTER: (1) SOLAREEDGE SE5000H-US

DESIGNED BY:	REV:
PRODUCTION: 6,149 KWH	

STAMP:	PV-2.0
	PAGE NAME: PLOT/SITE PLAN
	SCALE: 1/8" = 1'-0"
	DATE: 7/19/2022