

DOB STAMP

NO.	REVISIONS/SUBMISSIONS	DATE
	FOR PERMIT	07/29/22

DRAWN BY: KJ




SEAL


ENGINEER

PLUMBING ABBREVIATIONS	
DW	DISHWASHER
ICE	ICE MAKER
LAV	LAVATORY SINK
REFR	REFRIGERATOR
SHWR	SHOWER
SINK	KITCHEN SINK
TUB	TUB/SHOWER
WC	WATER CLOSET
WD	WASHER/DRYER
WH	WATER HEATER
HB	FIRE PROOF HOSE BIB

KEYNOTE LEGEND	
A302-B001	CONNECT TO SEWER PIPE.
A302-B002	PROPOSED HOT WATER HEATER; PROVIDE THERMAL TRAP.
A302-B003	RELIEF VALVE.
A302-B004	CONNECT TO EXISTING DOMESTIC WATER SERVICE; CONTRACTOR TO V.I.F.
A302-B005	SHUT-OFF VALVE.

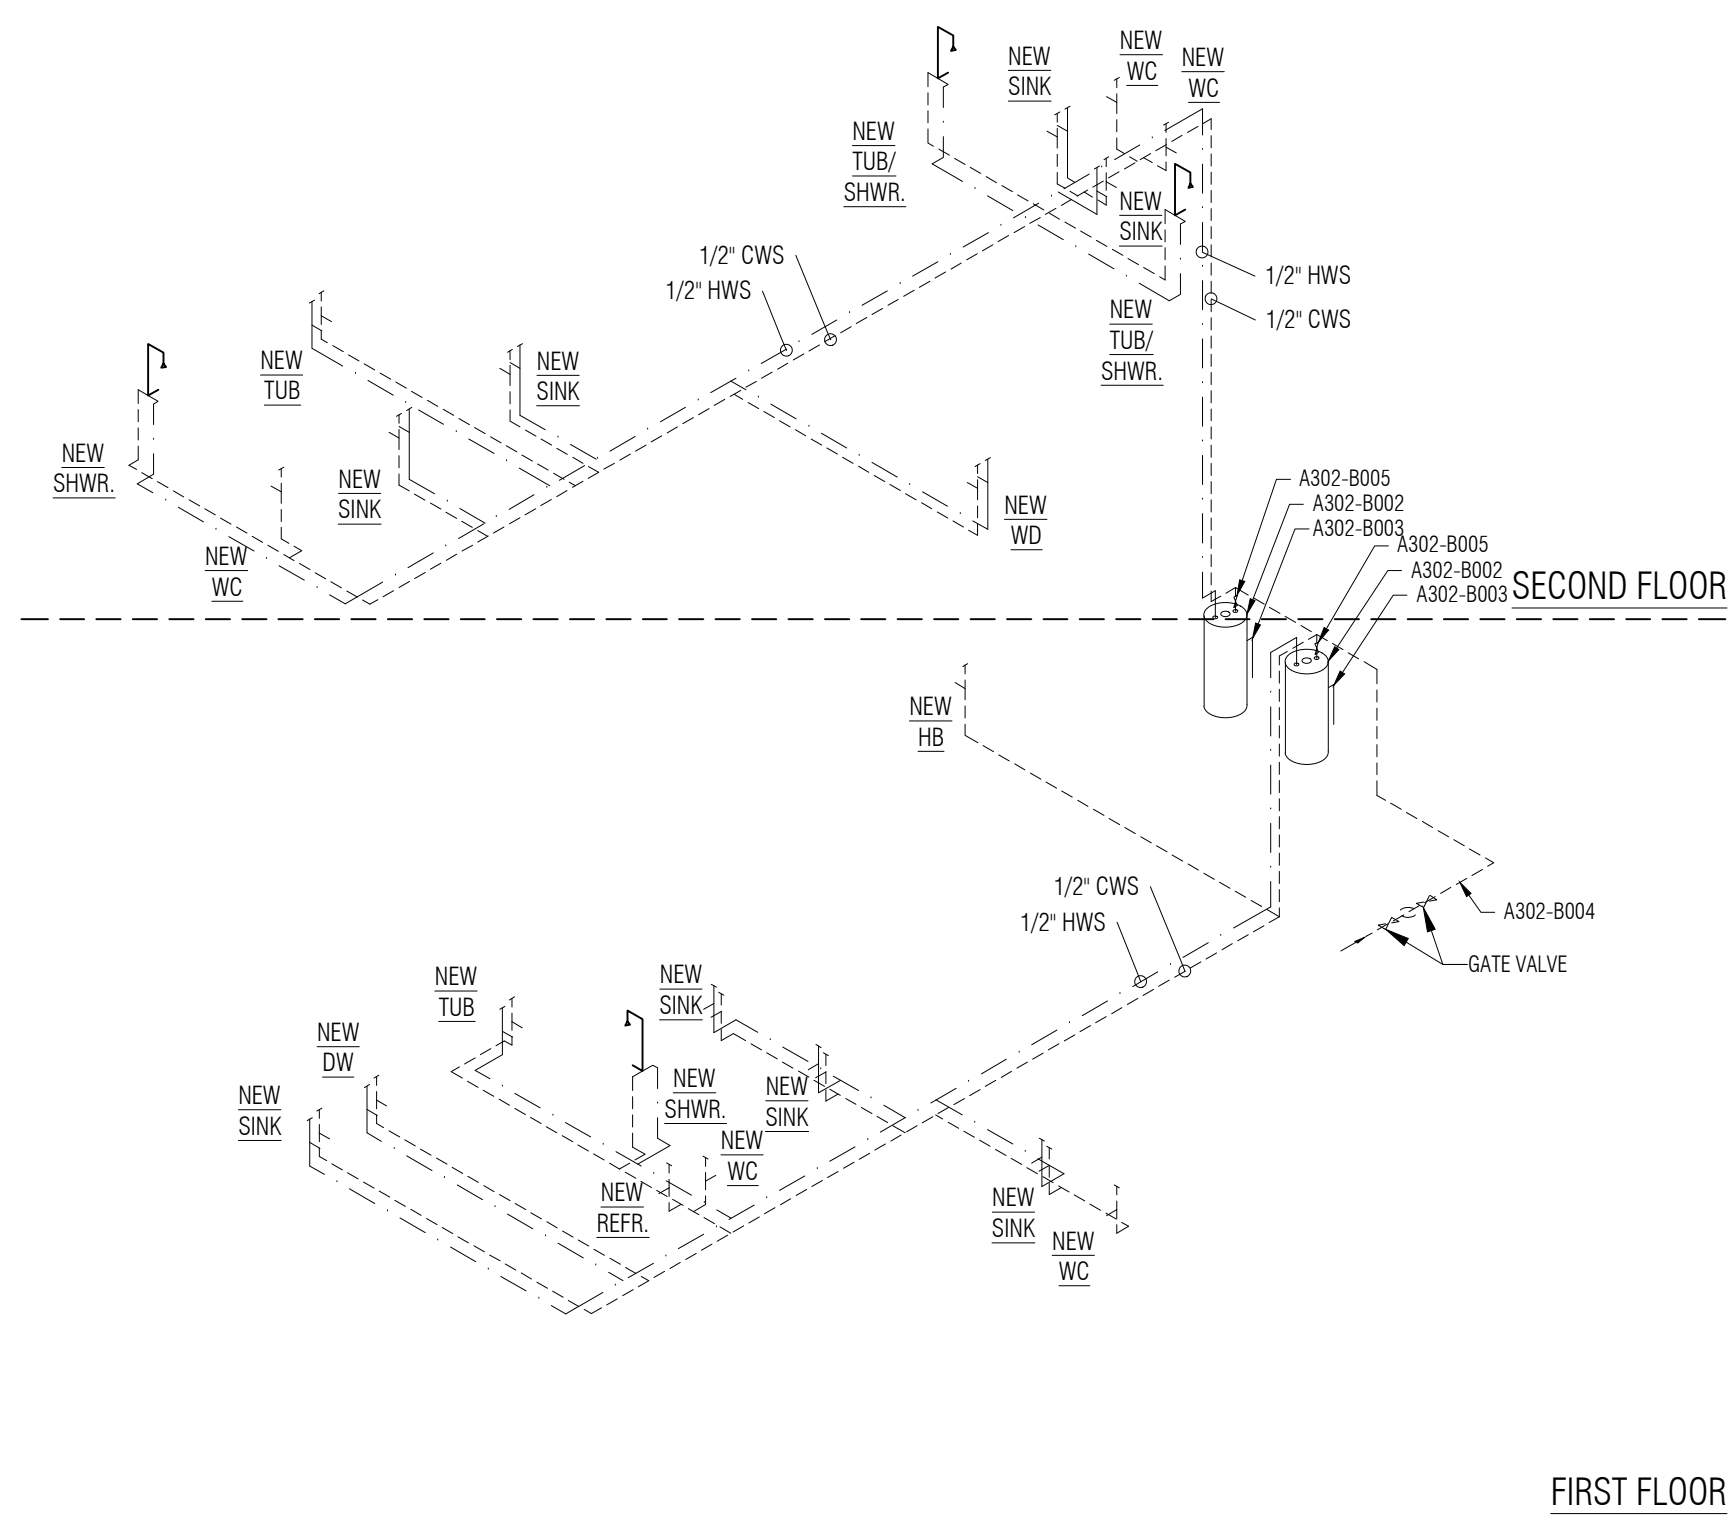

2 SUPPLY PIPE DIAGRAM
NOT TO SCALE

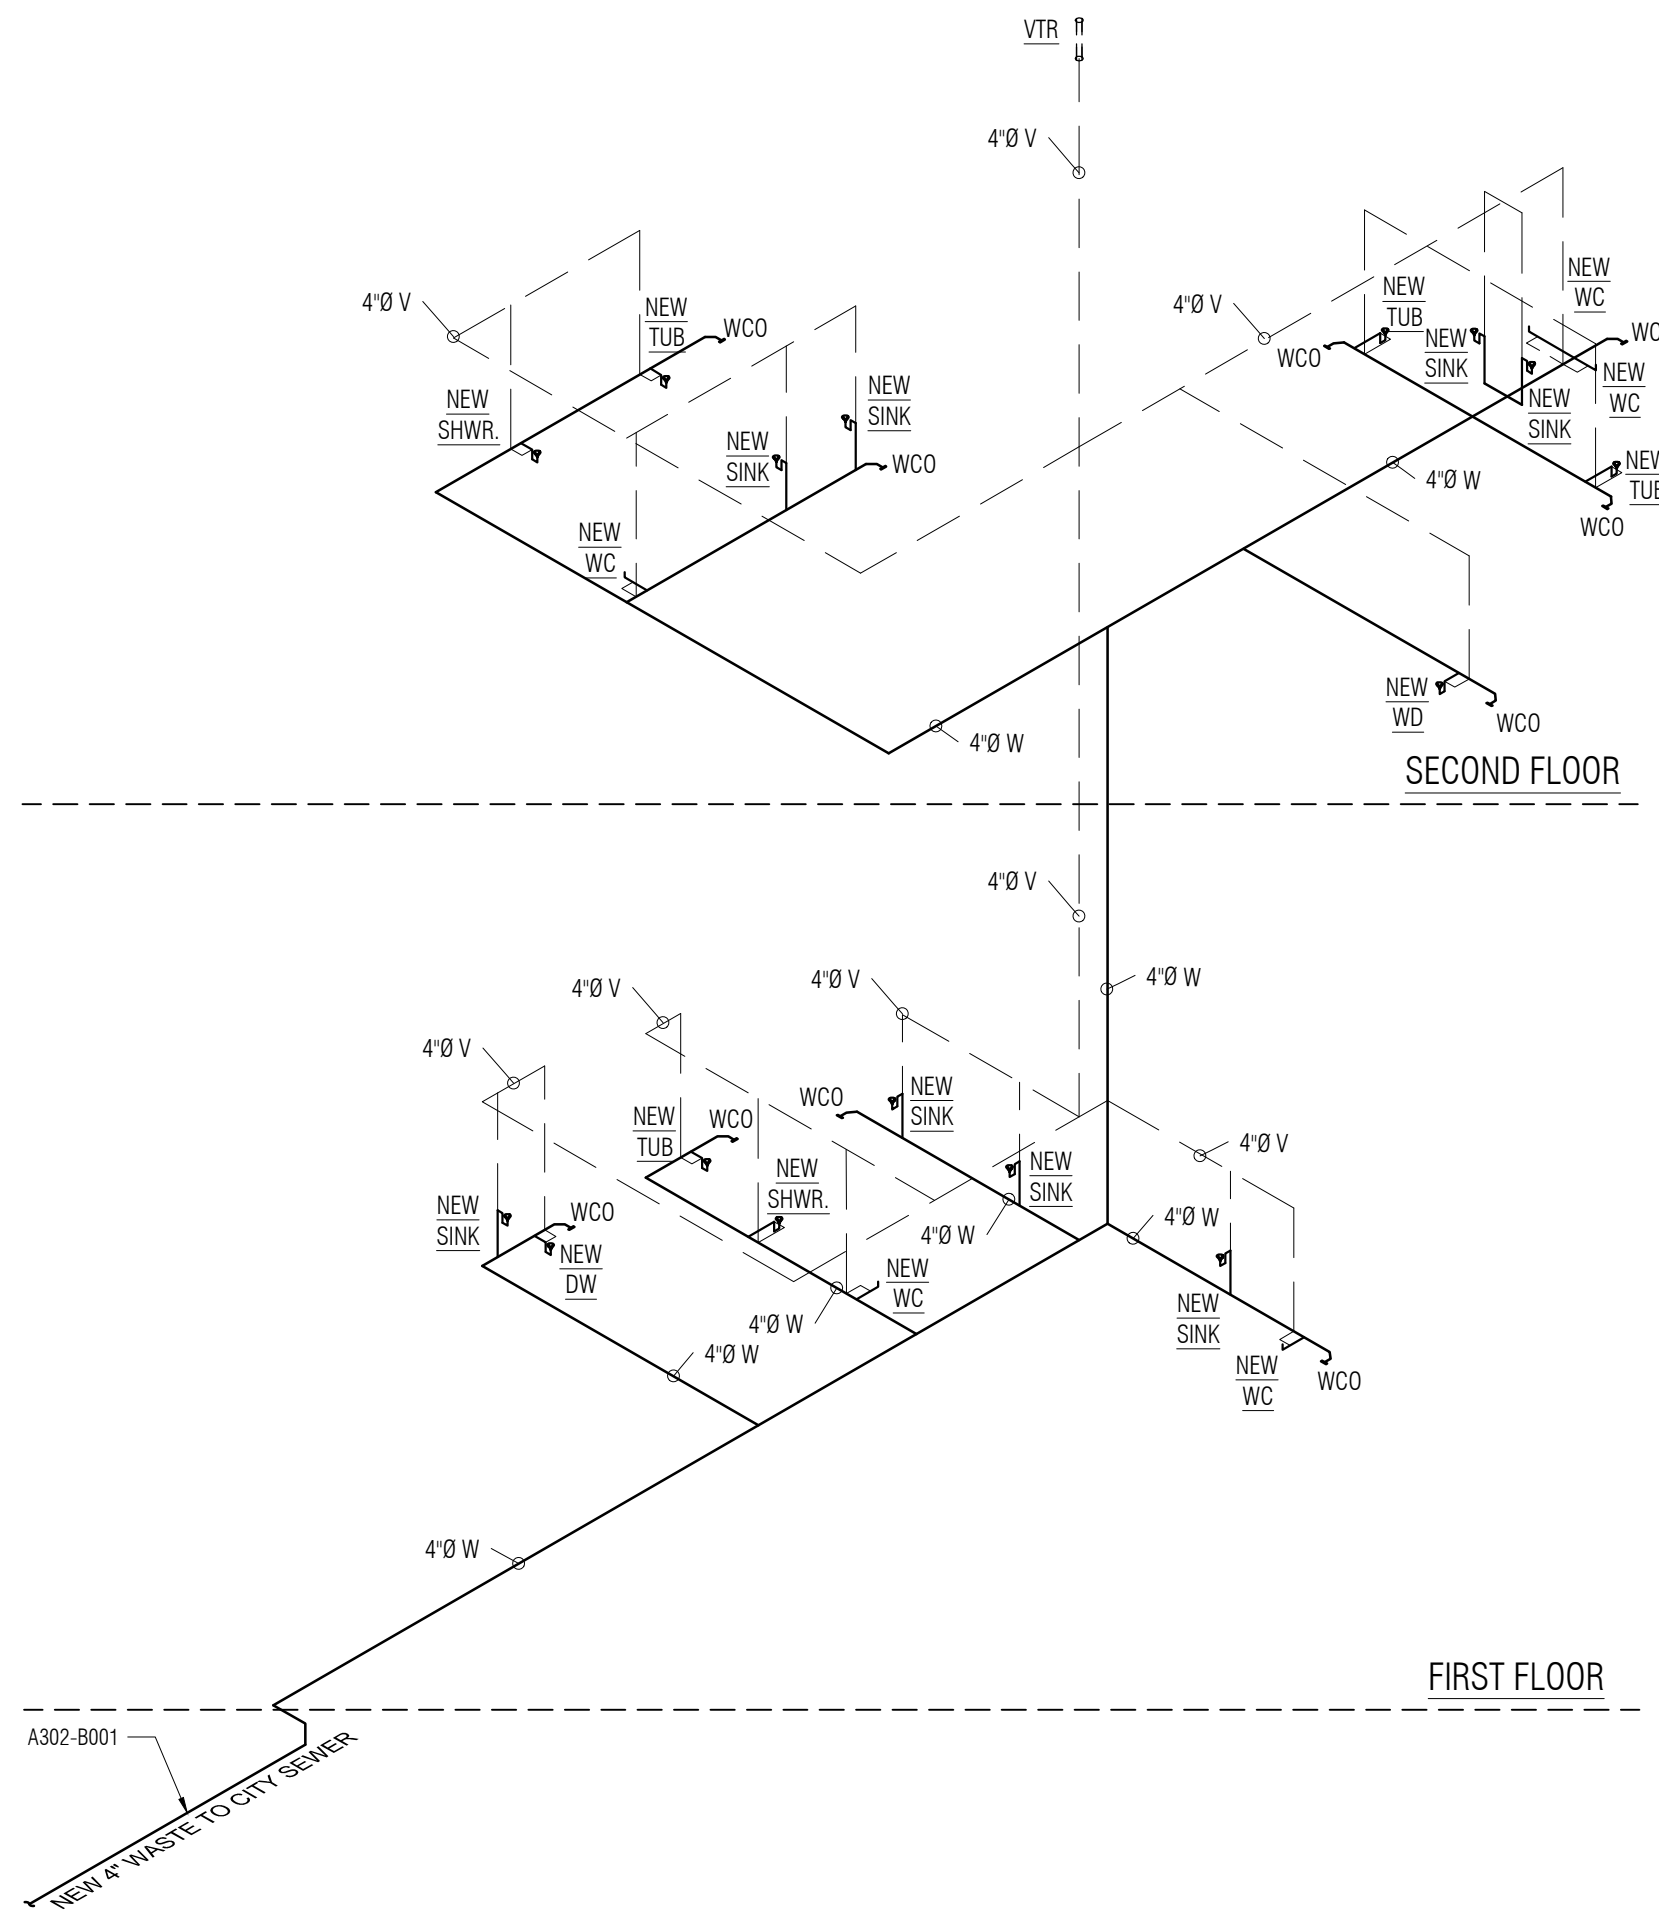

1 WASTE PIPE DIAGRAM
NOT TO SCALE

LOCATION:
PRIVATE RESIDENCE
5434 LAUREL STREET
NEW ORLEANS, LA 70115

DRAWING TITLE:
**PLUMBING RISER
DIAGRAMS**

PROJECT:
22-R-09

FOR PERMIT

A302
SHEET

KK JOHNSON ARCHITECTURE & DESIGN
4618 Camp Street, New Orleans, LA 70115
p: 504.327.8717 e: kjohnson@kjohnsonarchitecture.com

