 
 

 

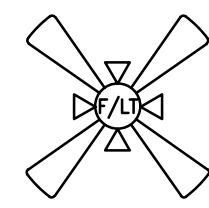
 
 
 
 

 
 


 

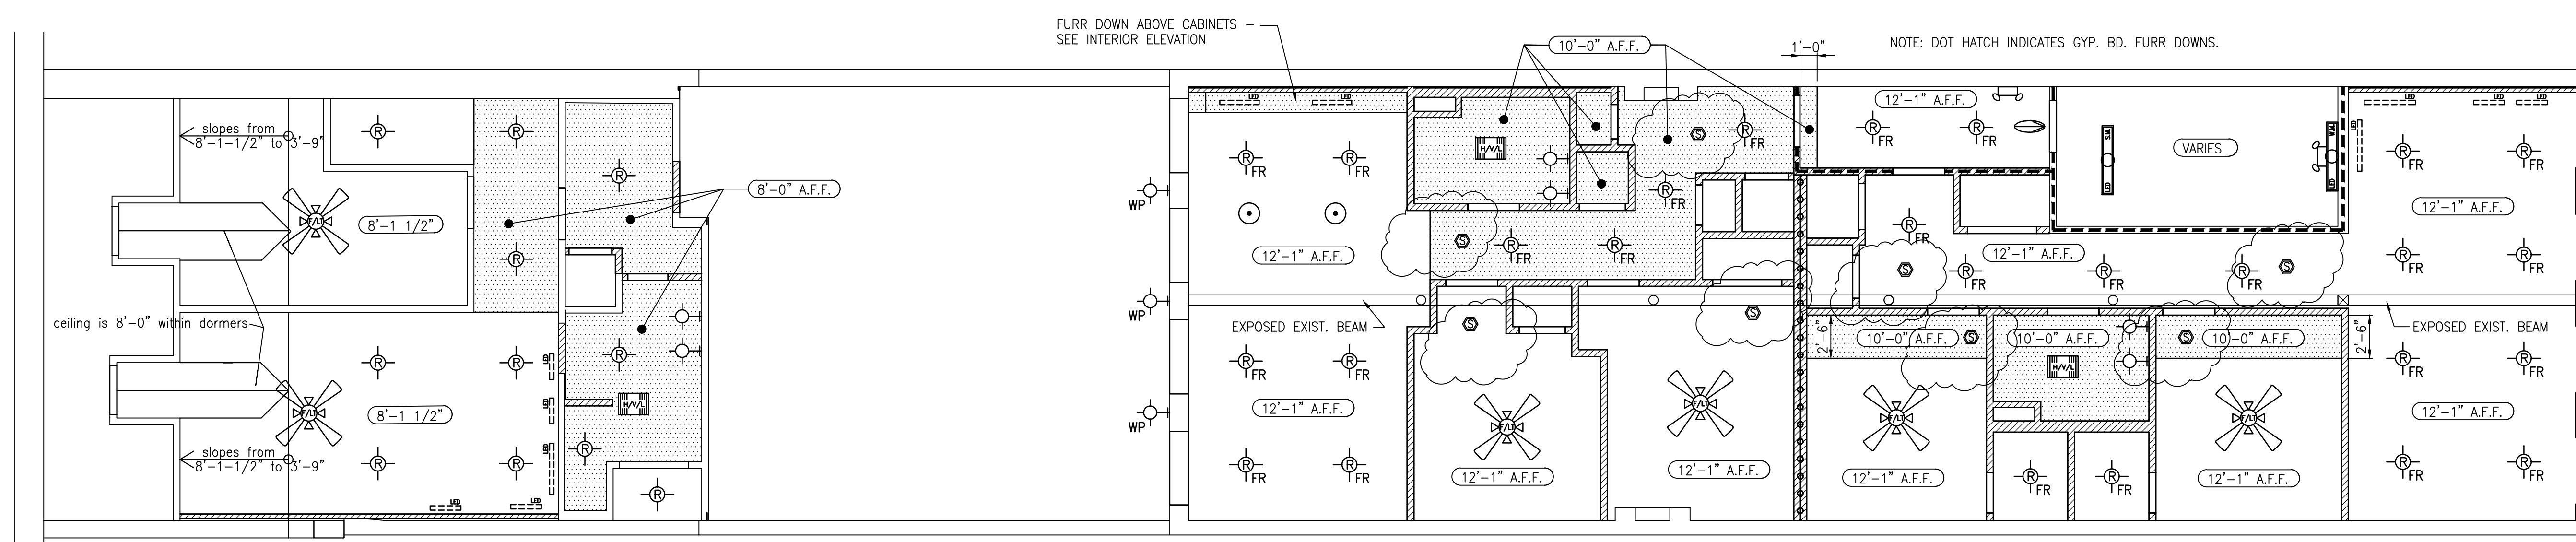


NOTE: ALL FURR DOWNS TO BE FRAMED WITH METAL STUDS.

CEILING LEGEND

-  NEW 2'x4' LIGHT FIXTURE
-  NEW 2'x4' LIGHT FIXTURE
-  SURFACE MOUNTED TRACK LIGHTING
-  RECESSED LIGHT FIXTURE
-  FIRE RATED RECESSED LIGHT FIXTURE
-  CEILING FAN W/ LIGHT KIT
-  WALL MOUNTED SCONCE
-  PENDANT MOUNTED LIGHT FIXTURE
-  SURFACE MOUNTED LIGHT FIXTURE
-  WALL MOUNTED LIGHT FIXTURE
-  UNDER CABINET LIGHT
-  WALL MOUNTED EXTERIOR SCONCE
-  HEATER/VENT/LIGHT (VENTED TO EXTERIOR)
-  VENT/LIGHT (VENTED TO EXTERIOR)
-  NEW FIRE EXIT INDICATOR SIGN/LIGHT
-  NEW BATTERY POWERED EMERGENCY LIGHT
-  SMOKE DETECTOR

1 NEW FIRST FLOOR REFLECTED CEILING PLAN
SCALE: 3/16"=1'-0"



NOTE: ALL FURR DOWNS TO BE FRAMED WITH METAL STUDS.

2 NEW SECOND FLOOR REFLECTED CEILING PLAN
SCALE: 3/16"=1'-0"



**New Bakery & Apartments at
317 Chartres St.
New Orleans, Louisiana 70130**

SCALE: AS SHOWN FILE NAME: 21036\Plan03.C

DATE: Dec. 28, 2021

STEVEN J. FINEGAN ARCHITECTS, LTD.
A PROFESSIONAL CORPORATION
123 S. Pierce St. - New Orleans, LA 70119
(504)486-5744 www.stevfineganarchitect.com
E-mail: stevfinegan@nocoxmail.com

NO.	DATE	REVISIONS

A9.0

This drawing is the property of STEVEN J. FINEGAN ARCHITECTS, LTD. It is not to be reproduced, copied or altered in whole or in part. It is not to be used for any purpose without the approval of STEVEN J. FINEGAN ARCHITECTS LTD. and is to be returned on request.