



APPROVED
maevans , 9/6/2022 ,1:31:51 PM

PLUMBING RISER DIAGRAM

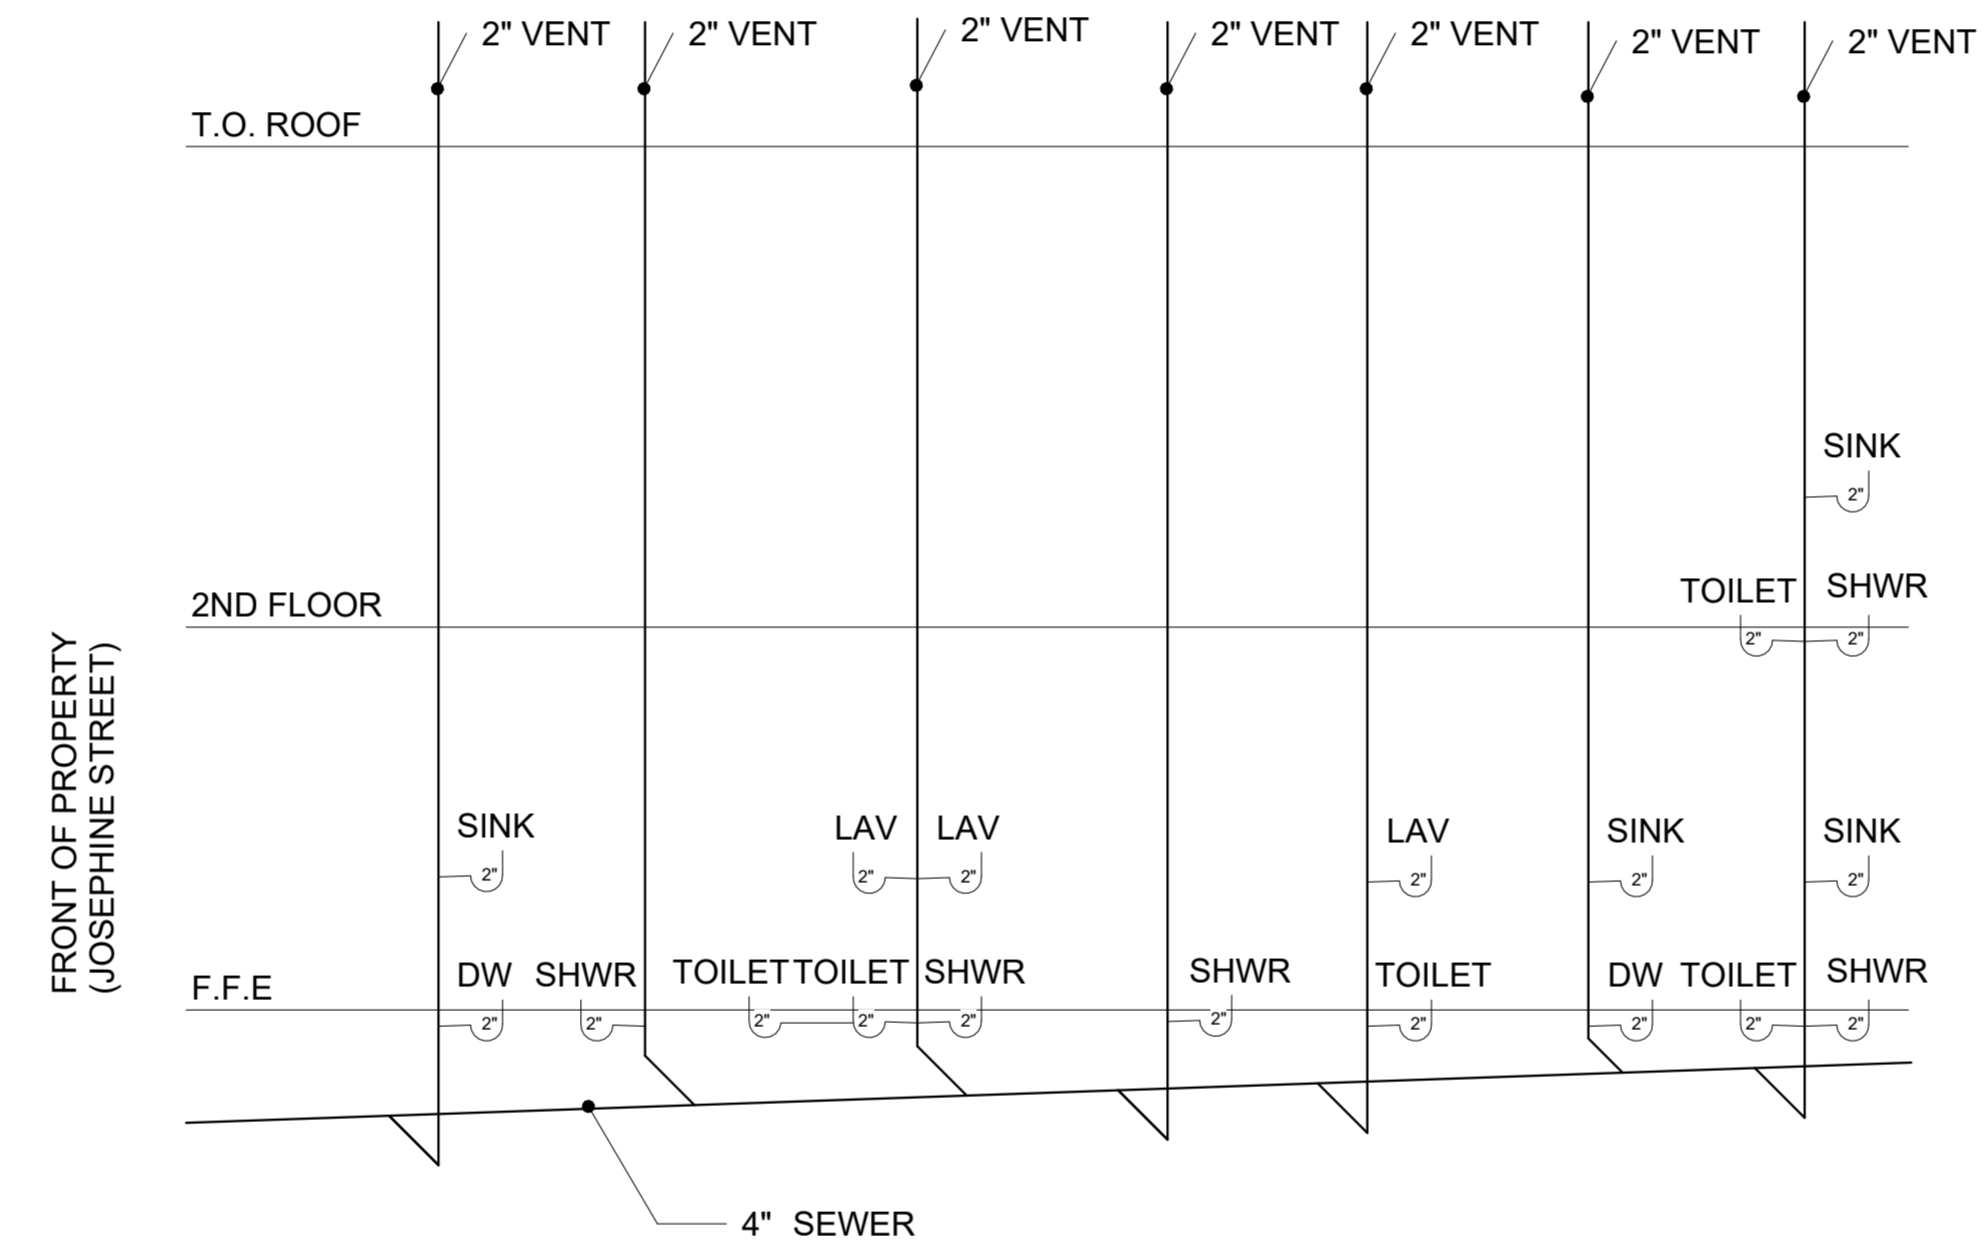

NOTE: VENT TO ATMOSPHERE

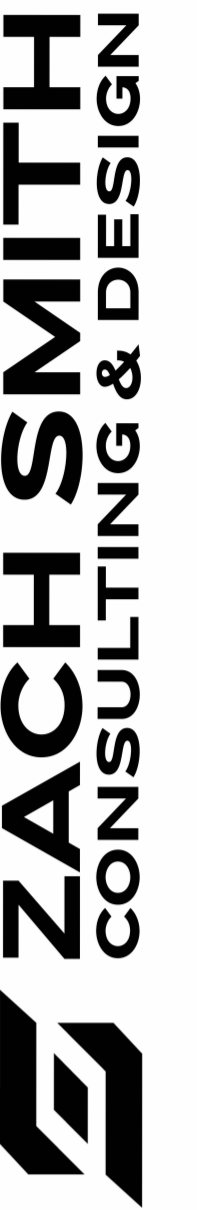

530 S Norman C Francis Parkway Suite 102
New Orleans, LA 70119
zach@zachsmithconsulting.com
+1 (504) 383-3748

228 JOSEPHINE STREET
New Orleans, LA 70113

No.	Description	Date

PLUMBER RISER
DIARAM

Project name 2228 JOSEPHINE
Project number 00000
Date 08/23/2022
Drawn by MG
Checked by Checker

A600