



PERMIT REVIEW

NOT FOR CONSTRUCTION

APPROVED  
maevans , 8/29/2022 ,6:51:11 AM

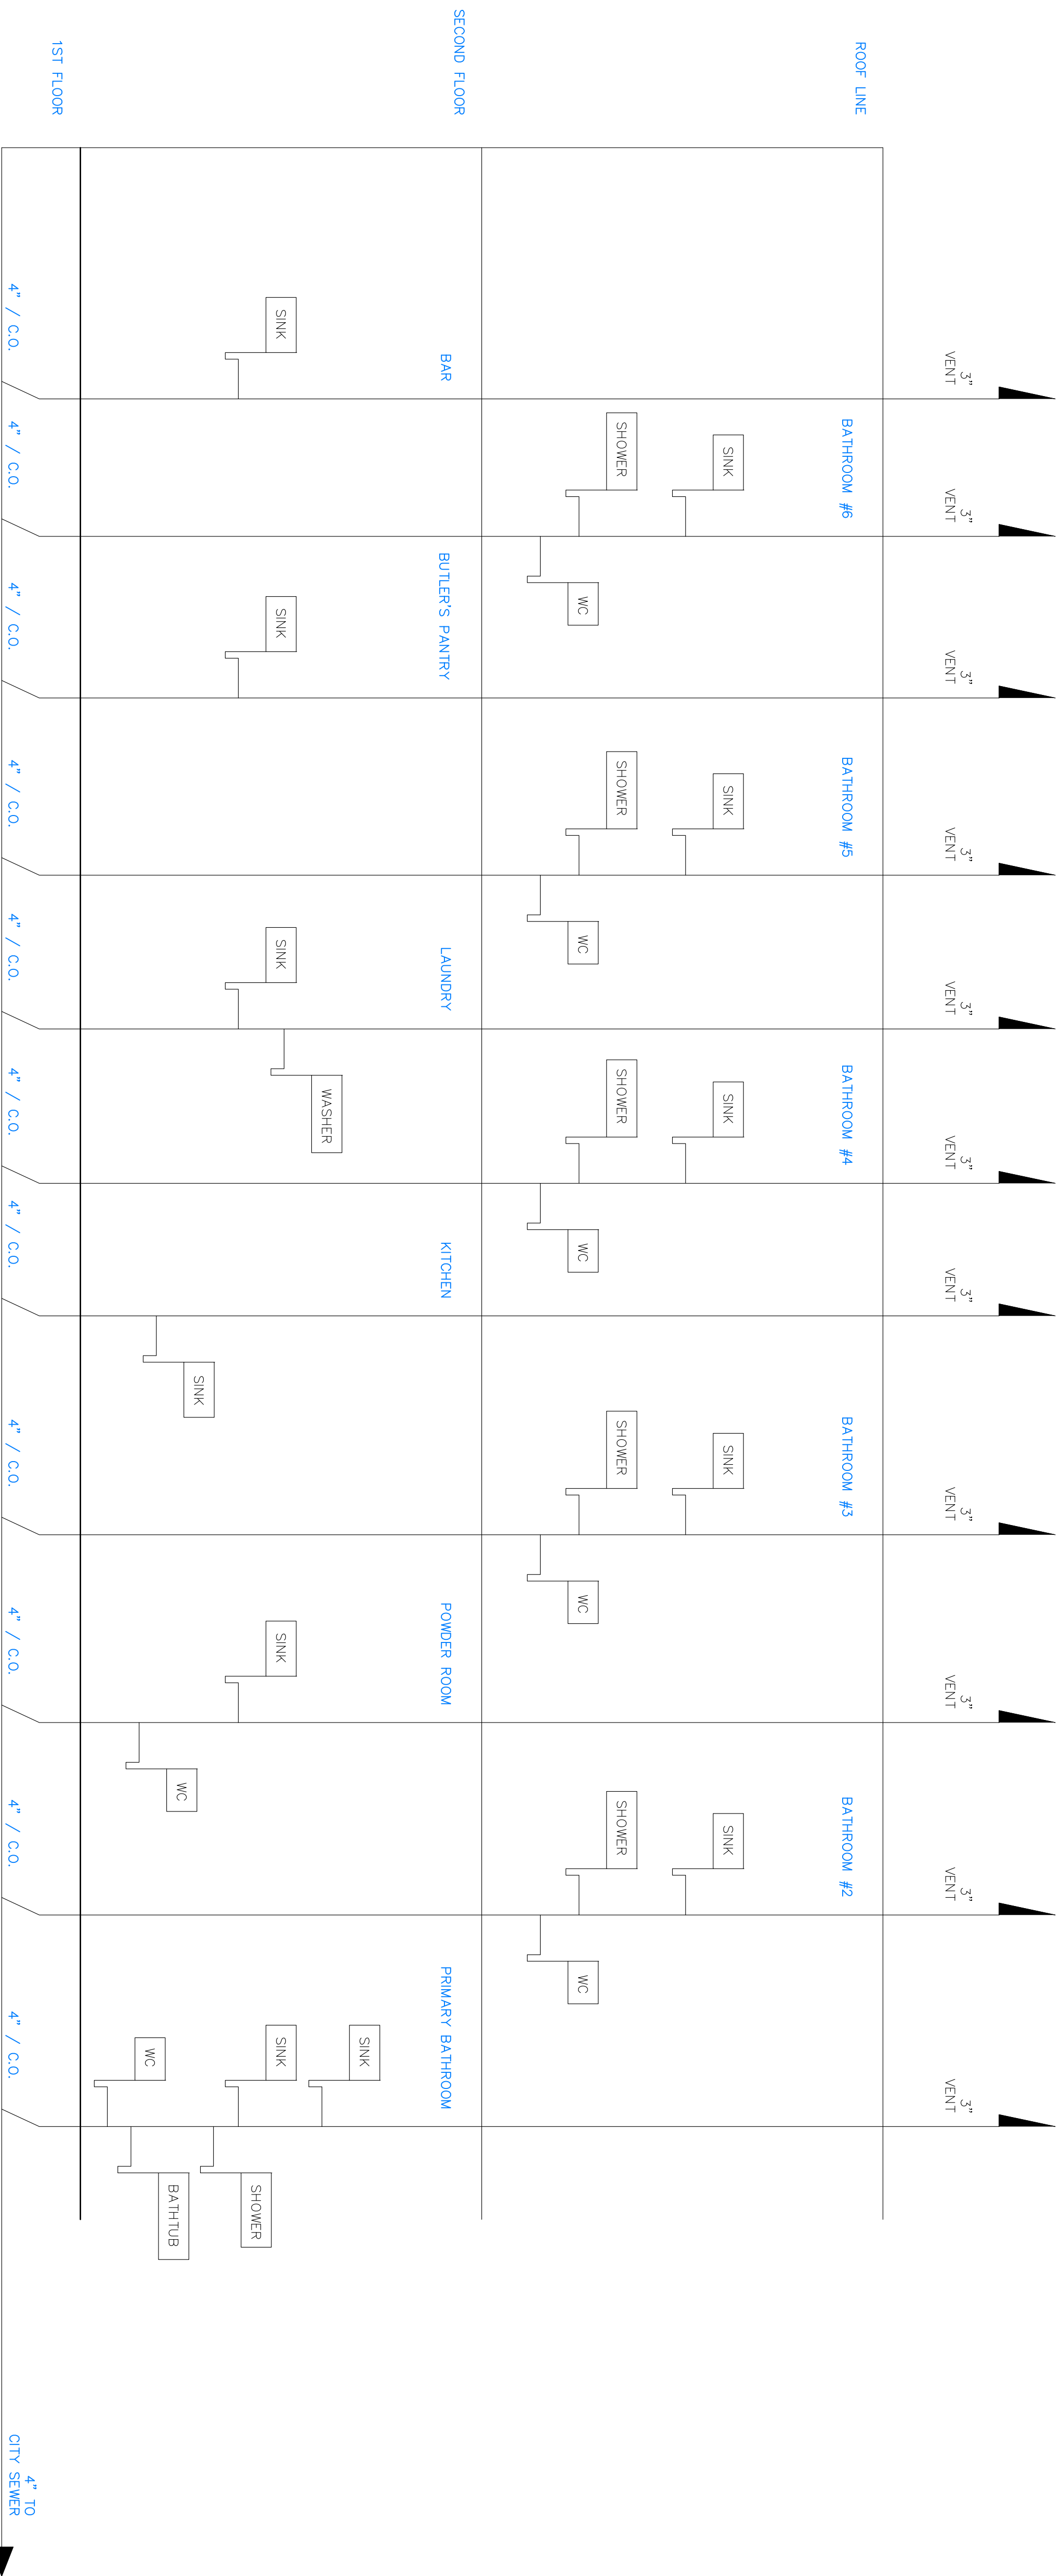

**1** Plumbing Riser Diagram  
SCALE: NTS

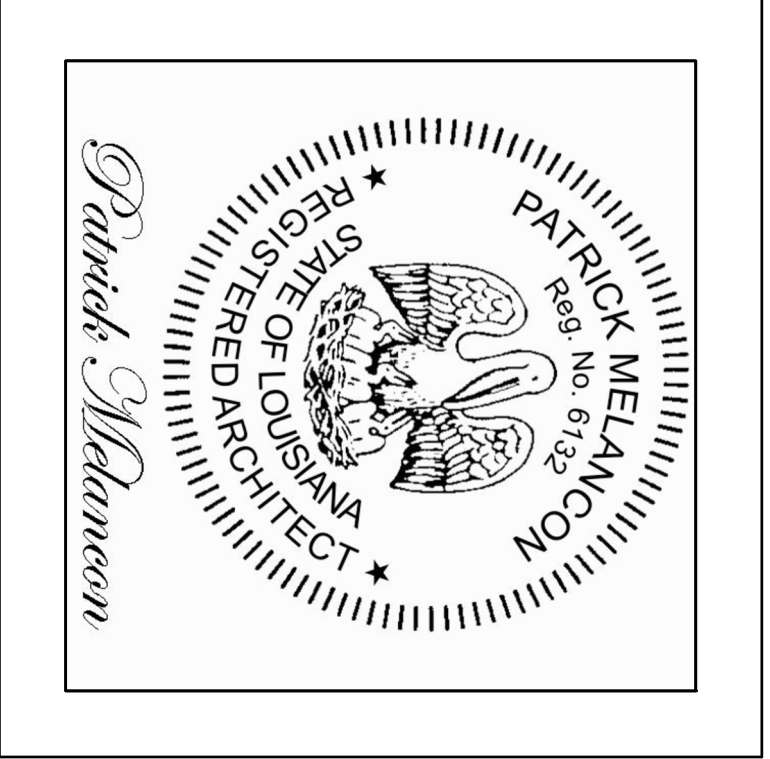

Additions & Renovations  
 Proposed For  
 1230 Webster Street  
 New Orleans, LA 70118

**Plumbing Riser Diagram**  
 Sheet #: X of —

Project #:	Revision:
Date: 08-25-2022	Revision:
Scale:	
Drawn By:	
Checked By:	
Revision:	
Revision:	

**P-1.01.0**