


**APPROVED**  
maevans , 9/13/2022 , 9:25:47 AM

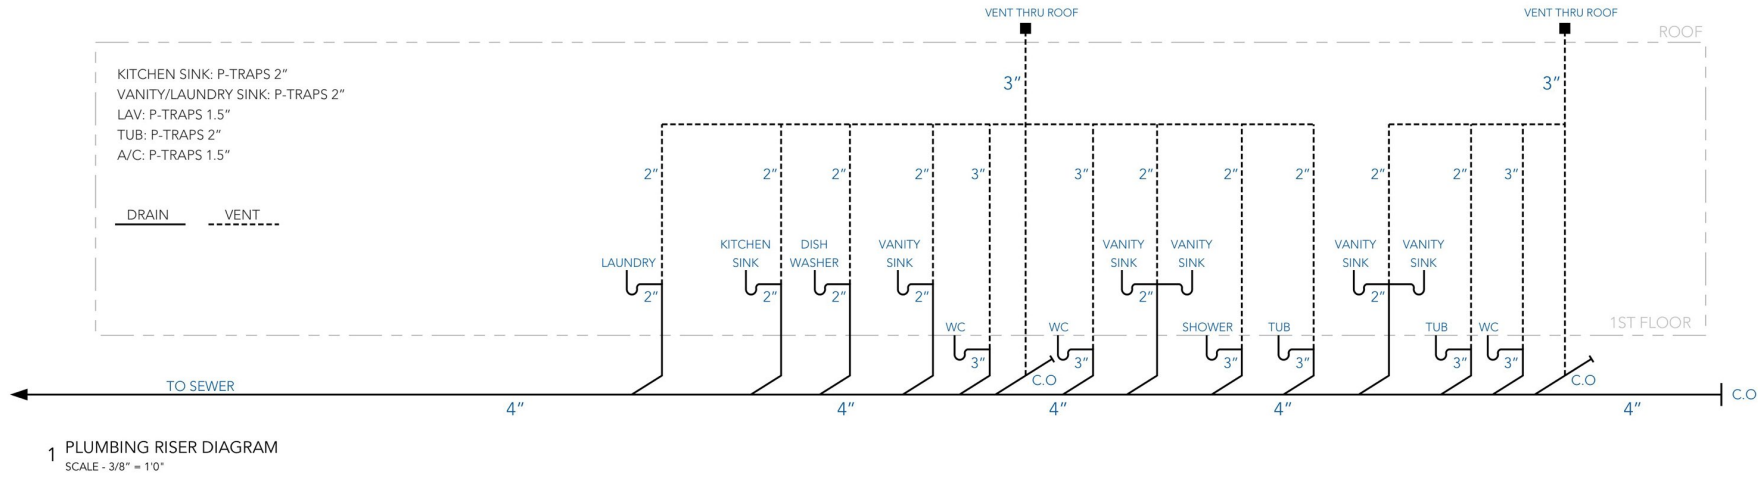

**PLUMBING NOTES**

1. GENERAL CONTRACTOR RESPONSIBLE FOR PROVIDING DESIGN/BUILD PLUMBING SERVICES FOR PROJECT.
2. WORK TO COMPLY WITH ALL APPLICABLE CODES. WORK TO BE COORDINATED AND REVIEWED FOR COMPLIANCE WITH DESIGN REQUIREMENTS PRIOR TO INSTALL.
3. ALL WORK SHALL BE PERFORMED BY LICENSED INDIVIDUALS TO PERFORM THEIR SAID WORK, AS OUTLINED BY LAW.
4. SEE FLOOR PLAN FOR BASIC PLUMBING FIXTURES. NOT ALL EQUIPMENT AND FIXTURES ARE SHOWN OR NOTED. PLUMBING CONTRACTOR TO PROVIDE ALL NECESSARY PARTS AND EQUIPMENT FOR COMPLETE INSTALLATION.
5. HOT WATER AND DRAIN PIPES SHALL BE INSULATED OR OTHERWISE CONFIGURED TO PROTECT AGAINST CONTACT. THERE SHALL BE NO SHARP OR ABRASIVE SURFACES UNDER LAVATORIES.
6. WASTE LINES AND VENTS P.V.C SCH 40. SUPPLY LINES PEX.
7. PRESSURE TEST PRIOR TO CONCEALMENTS
8. FIXTURE SELECTION BY OWNER



**LC**

www.land-cover.net

**CLIENT**  
B Vertical LLC  
117 Raspberry St. Apt. C  
Metairie, LA 70005

**ENGINEER**  
Thomas M. Smith P.E.  
Civil Engineer  
6516 Boutall St, Metairie, LA  
504-887-3882/504-247-6294

**ISSUE**  
9.2.22  
**DRAWN BY**  
Land Cover

**PROJECT**  
New Construction  
1472 Harrison Ave.  
New Orleans, LA 70122

**Plumbing Riser Diagram**