




NORTHGATE DR

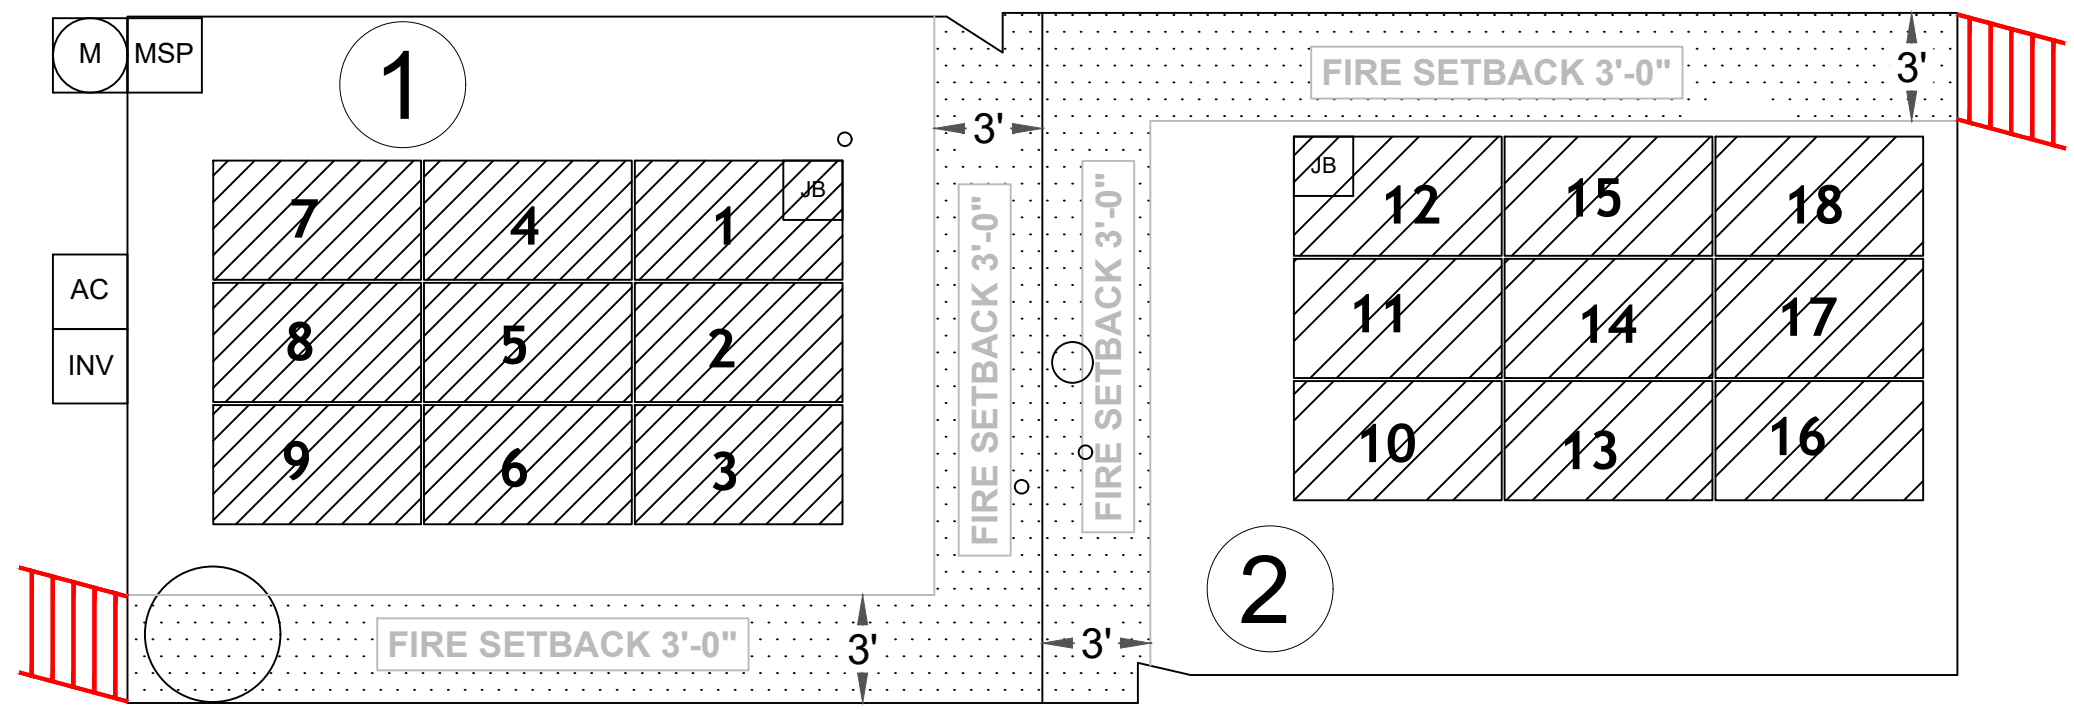

P-002869

GG18062

7131 NORTHGATE DR
NEW ORLEANS, LA 70128

○ FIRE CODE OFFSET
 ▨ GROUND ACCESS POINT

CNO
OPP # 178583

STRING'S

▨ STRING #1 - 9 MODULES
 ▨ STRING #2 - 9 MODULES

ROOF SECTION(S):

①	SLOPE:	16
	MODULE:	9
	AZIMUTH:	233
②	SLOPE:	16
	MODULE:	9
	AZIMUTH:	53

7.47 SE CANADIAN SOLAR 415

PosiGen
 Solar • Energy Efficiency • Roofing

POSIGEN DEVELOPER, LLC
 819 Central Ave, Suite 210
 Jefferson, LA 70121

JOB NUMBER: 178583		PRODUCTION: 8,362 kWh
UTILITY: ENTERGY NEW ORLEANS		
RACKING: K2 CROSS RAIL SYSTEM		
MODULES: (18) CANADIAN SOLAR CS3N-415MS		
OPTIMIZER: (18) SOLAREEDGE OPTIMIZER S440/P505		REV:
INVERTER: (1) SOLAREEDGE SE7600H-US		DESIGNED BY: KARAN RANA

Contractor is responsible for verifying all on-site conditions and measurements, complying with local and national code requirements and manufacturers' manuals.

PV-2.0

PAGE NAME:
PLOT/SITE PLAN

SCALE:
 3/16" = 1'-0"

DATE:
8/25/2022