


NOT FOR CONSTRUCTION

APPROVED  
maevans , 9/14/2022 , 12:02:04 PM

PLUMBING RISER DIAGRAM

NOTE: VENT TO ATMOSPHERE

FRONT OF PROPERTY  
(KENILWORTH ST.)

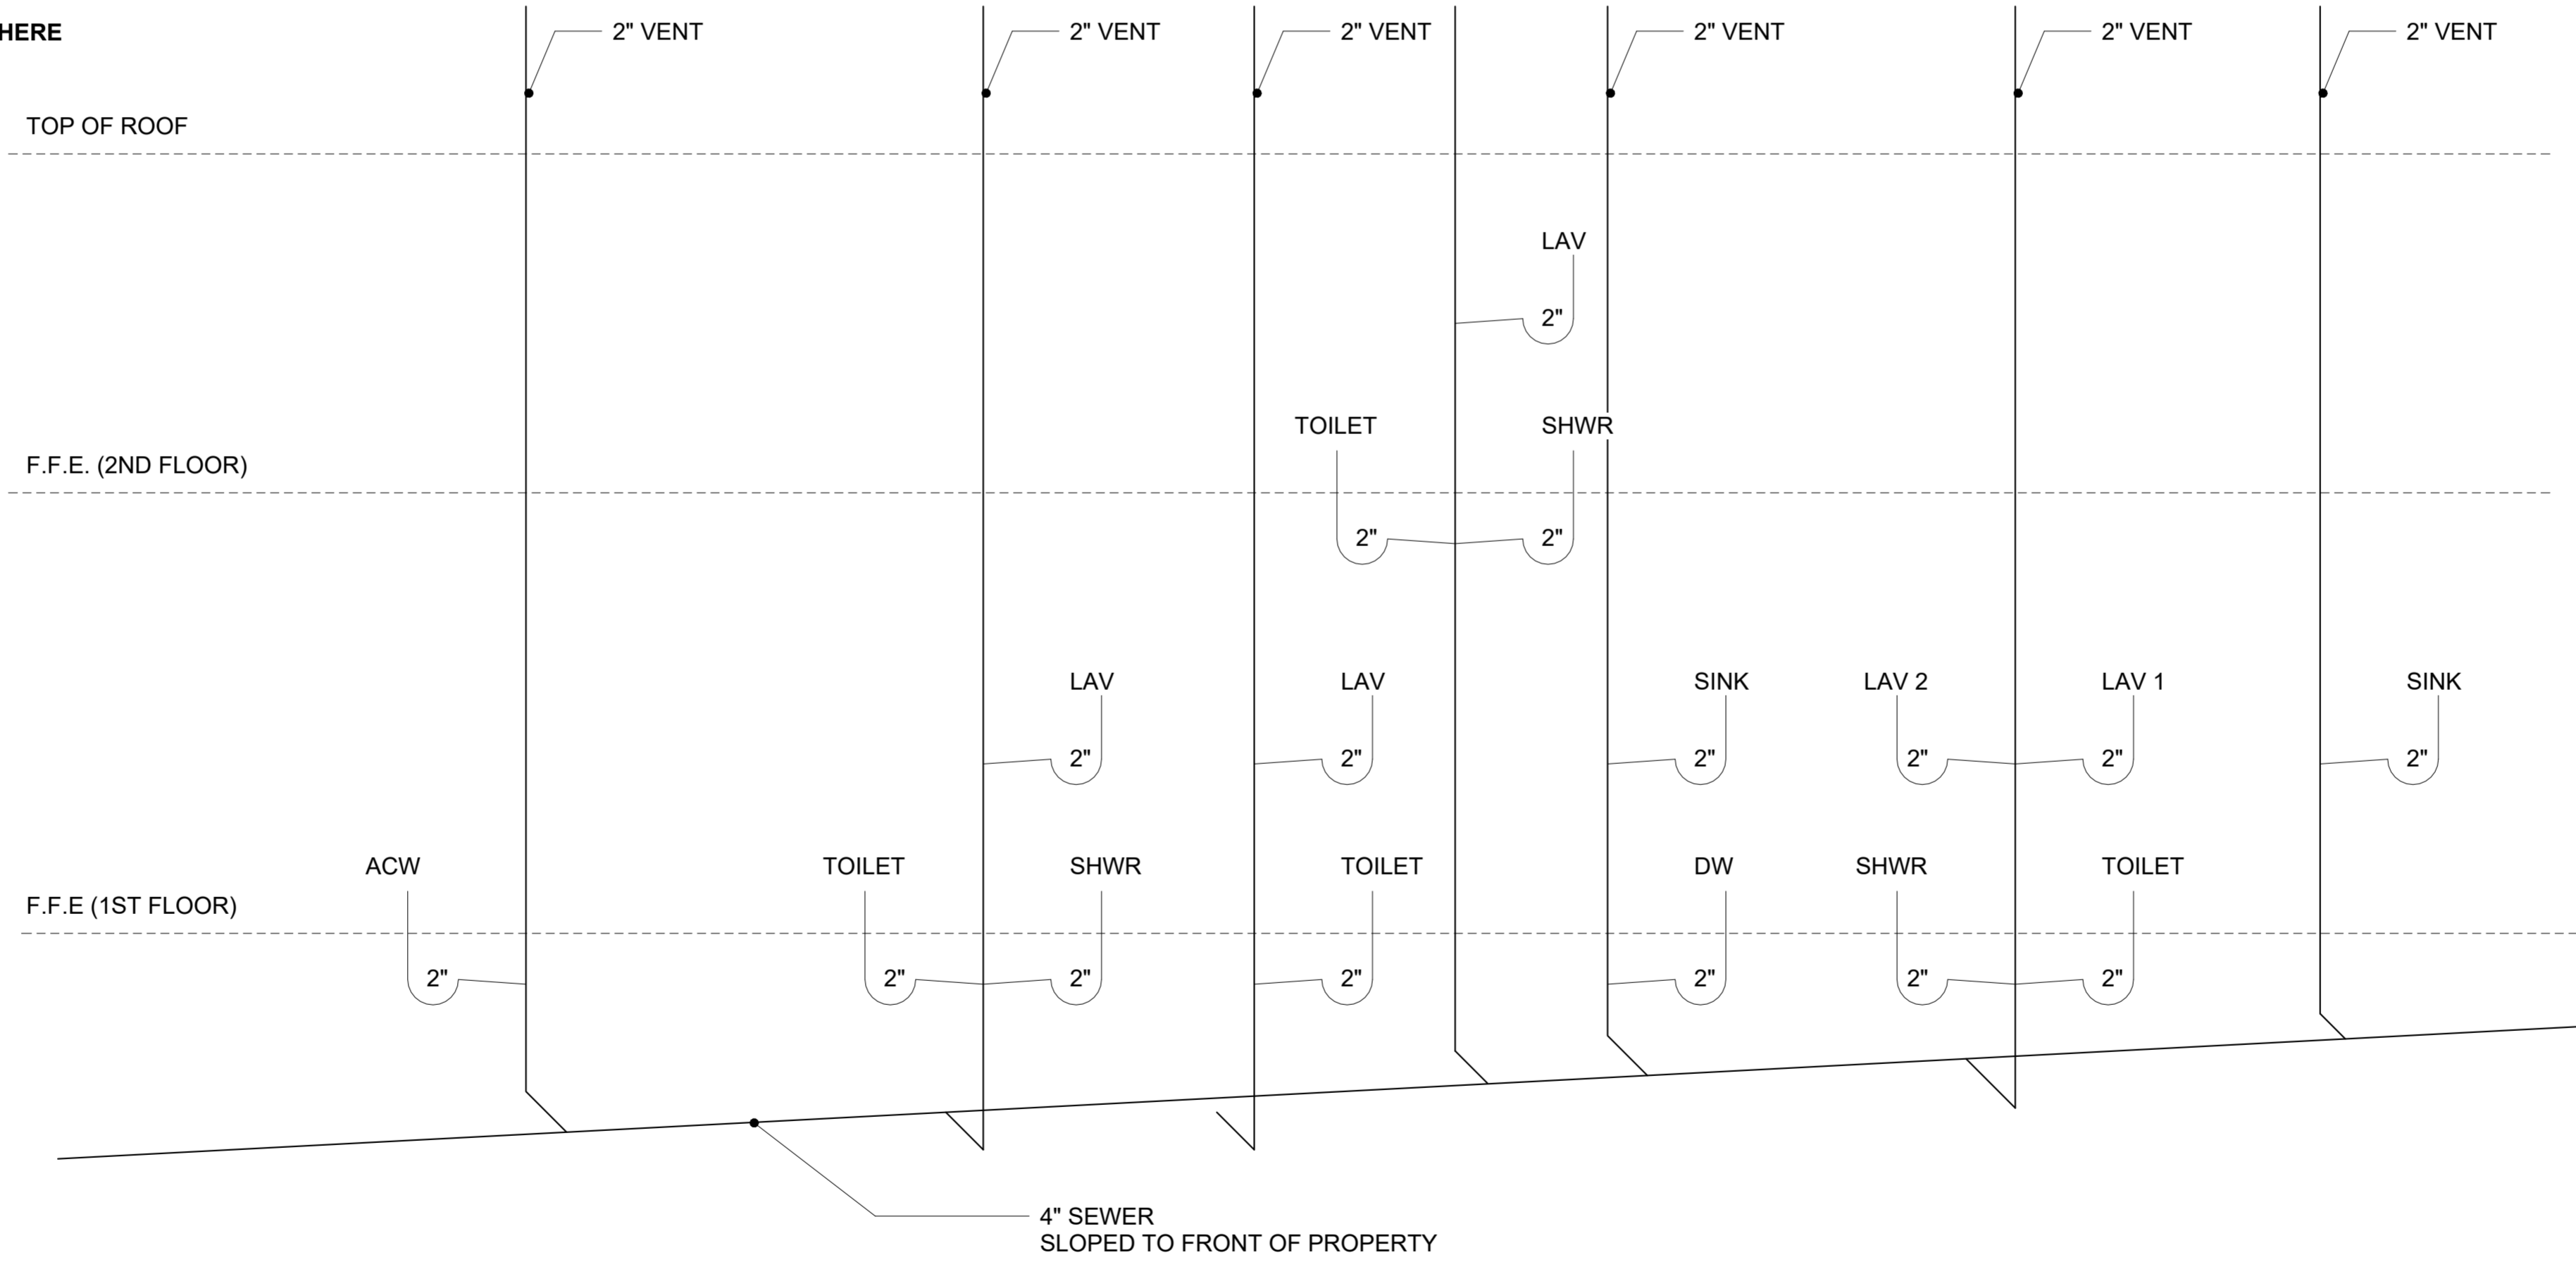


**ZACH SMITH**  
CONSULTING & DESIGN

530 S Norman C Francis Parkway Suite 102  
New Orleans, LA 70119  
zach@zachsmithconsulting.com  
+1 (504) 383-3748

5814 LOUISVILLE  
New Orleans, LA 20124

No.	Description	Date
5	Plumbing Riser Diagram	9_13_22

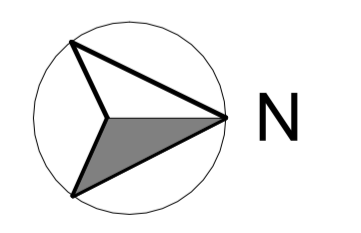

Plumbing Riser Diagram

Project name	5814 Louisville
Project number	22001LS
Date	09_13_22
Drawn by	MG
Checked by	ZS

A900