


NOTE :- "ALL BOS COMPONENTS SHALL BE INSTALLED WITHIN 10 FT OF ADJACENT COMPONENTS"

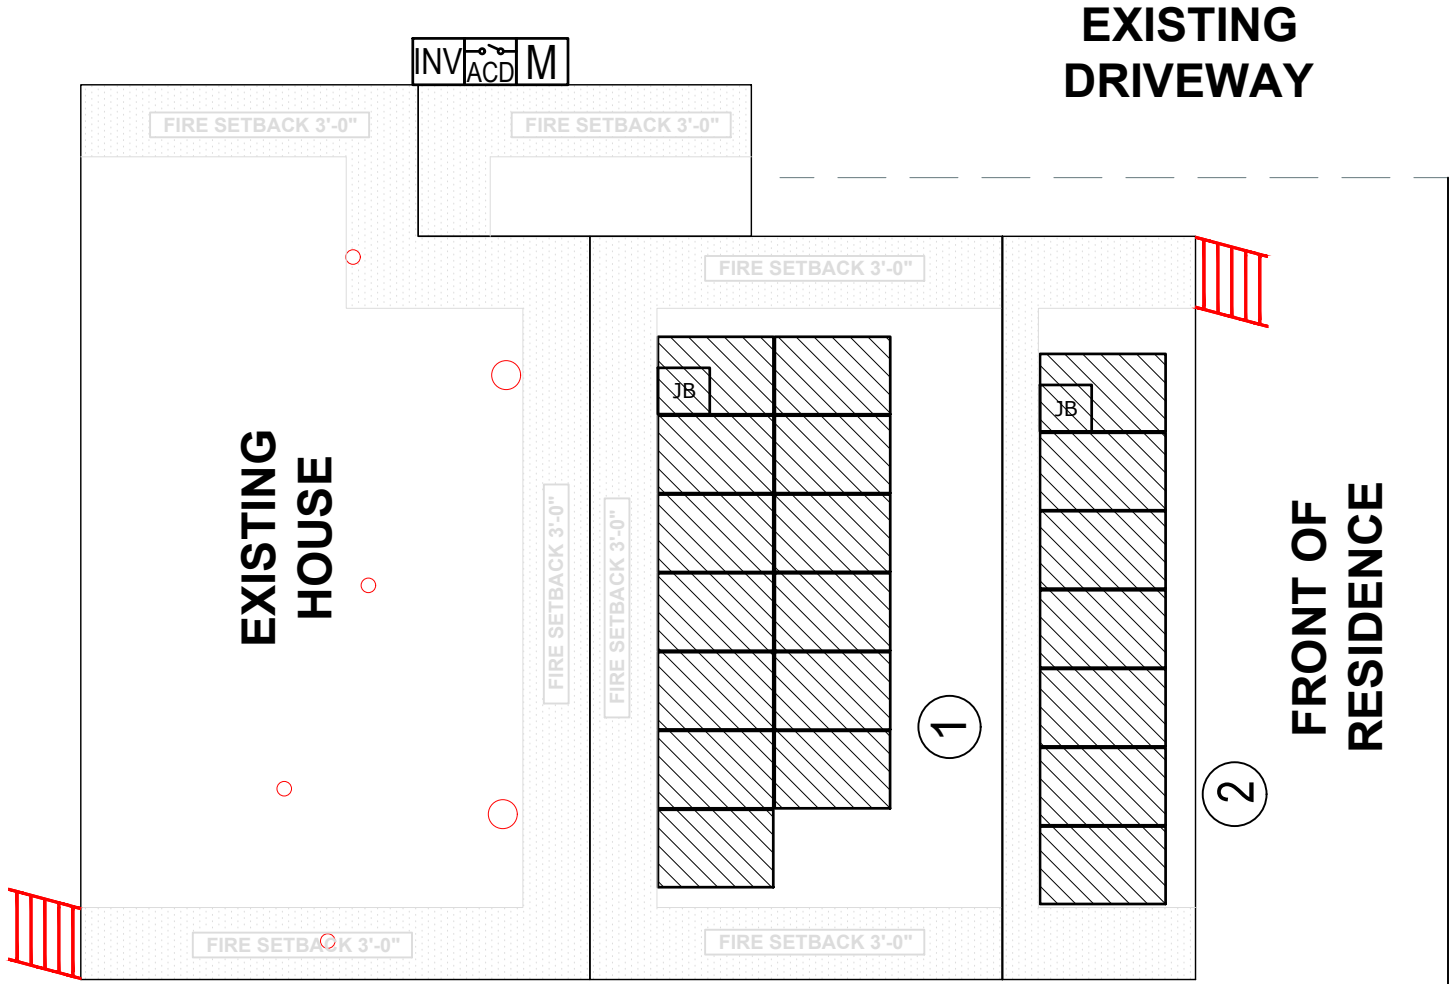

ROOF SECTION(S):

- ① SLOPE - 27
AZIMUTH - 95
MATERIAL - COMP. SHINGLE
- ② SLOPE - 14
AZIMUTH - 95
MATERIAL - COMP. SHINGLE

LEGEND

- METER
- PRODUCTION METER
- INVERTER
- AC DISCONNECT
- MAIN SERVICE PANEL
- JUNCTION BOX
- OBSTRUCTION
- DRIVEWAY
- SOLAR MODULE
- STRING #1
20 MODULE
- FIRE CODE OFFSET

POSIGEN DEVELOPER, LLC
819 CENTRAL AVE STE 210
JEFFERSON, LA 70121
LA ELECTRICAL LICENSE :74446

JOB NUMBER: P-004997
UTILITY: ENTERGY
RACKING: K2 CROSSRAIL SYSTEM
MODULES: (20)HIS-M250MG(SL)
OPTIMIZER: (20) SOLAREEDGE P300 OPTIMIZER
INVERTER: (1)SOLAREEDGE SE5000H-US

OWNER:
MELANIE VAUGHN,
5668 GENERAL DIAZ STREET NEW
ORLEANS ,LA 70124
ACCOUNT NUMBER : 93072171

DESCRIPTION:
MELANIE VAUGHN,
RESIDENCE
5.00 kWDC ROOF SOLAR SYSTEM
PRODUCTION: 5,463kWH
DESIGNED BY:
ENERQUAL

STAMP:
REV:

PV-2
PAGE NAME:
SITE PLAN
SCALE:
1/8" = 1'
DATE:
9/17/2022