




ZACHARY RYAN SMITH
REG. NO. 841
STATE OF LOUISIANA
REGISTERED ENGINEER

APPROVED
maevans , 10/19/2022 ,1:56:58 PM

PLUMBING RISER DIAGRAM

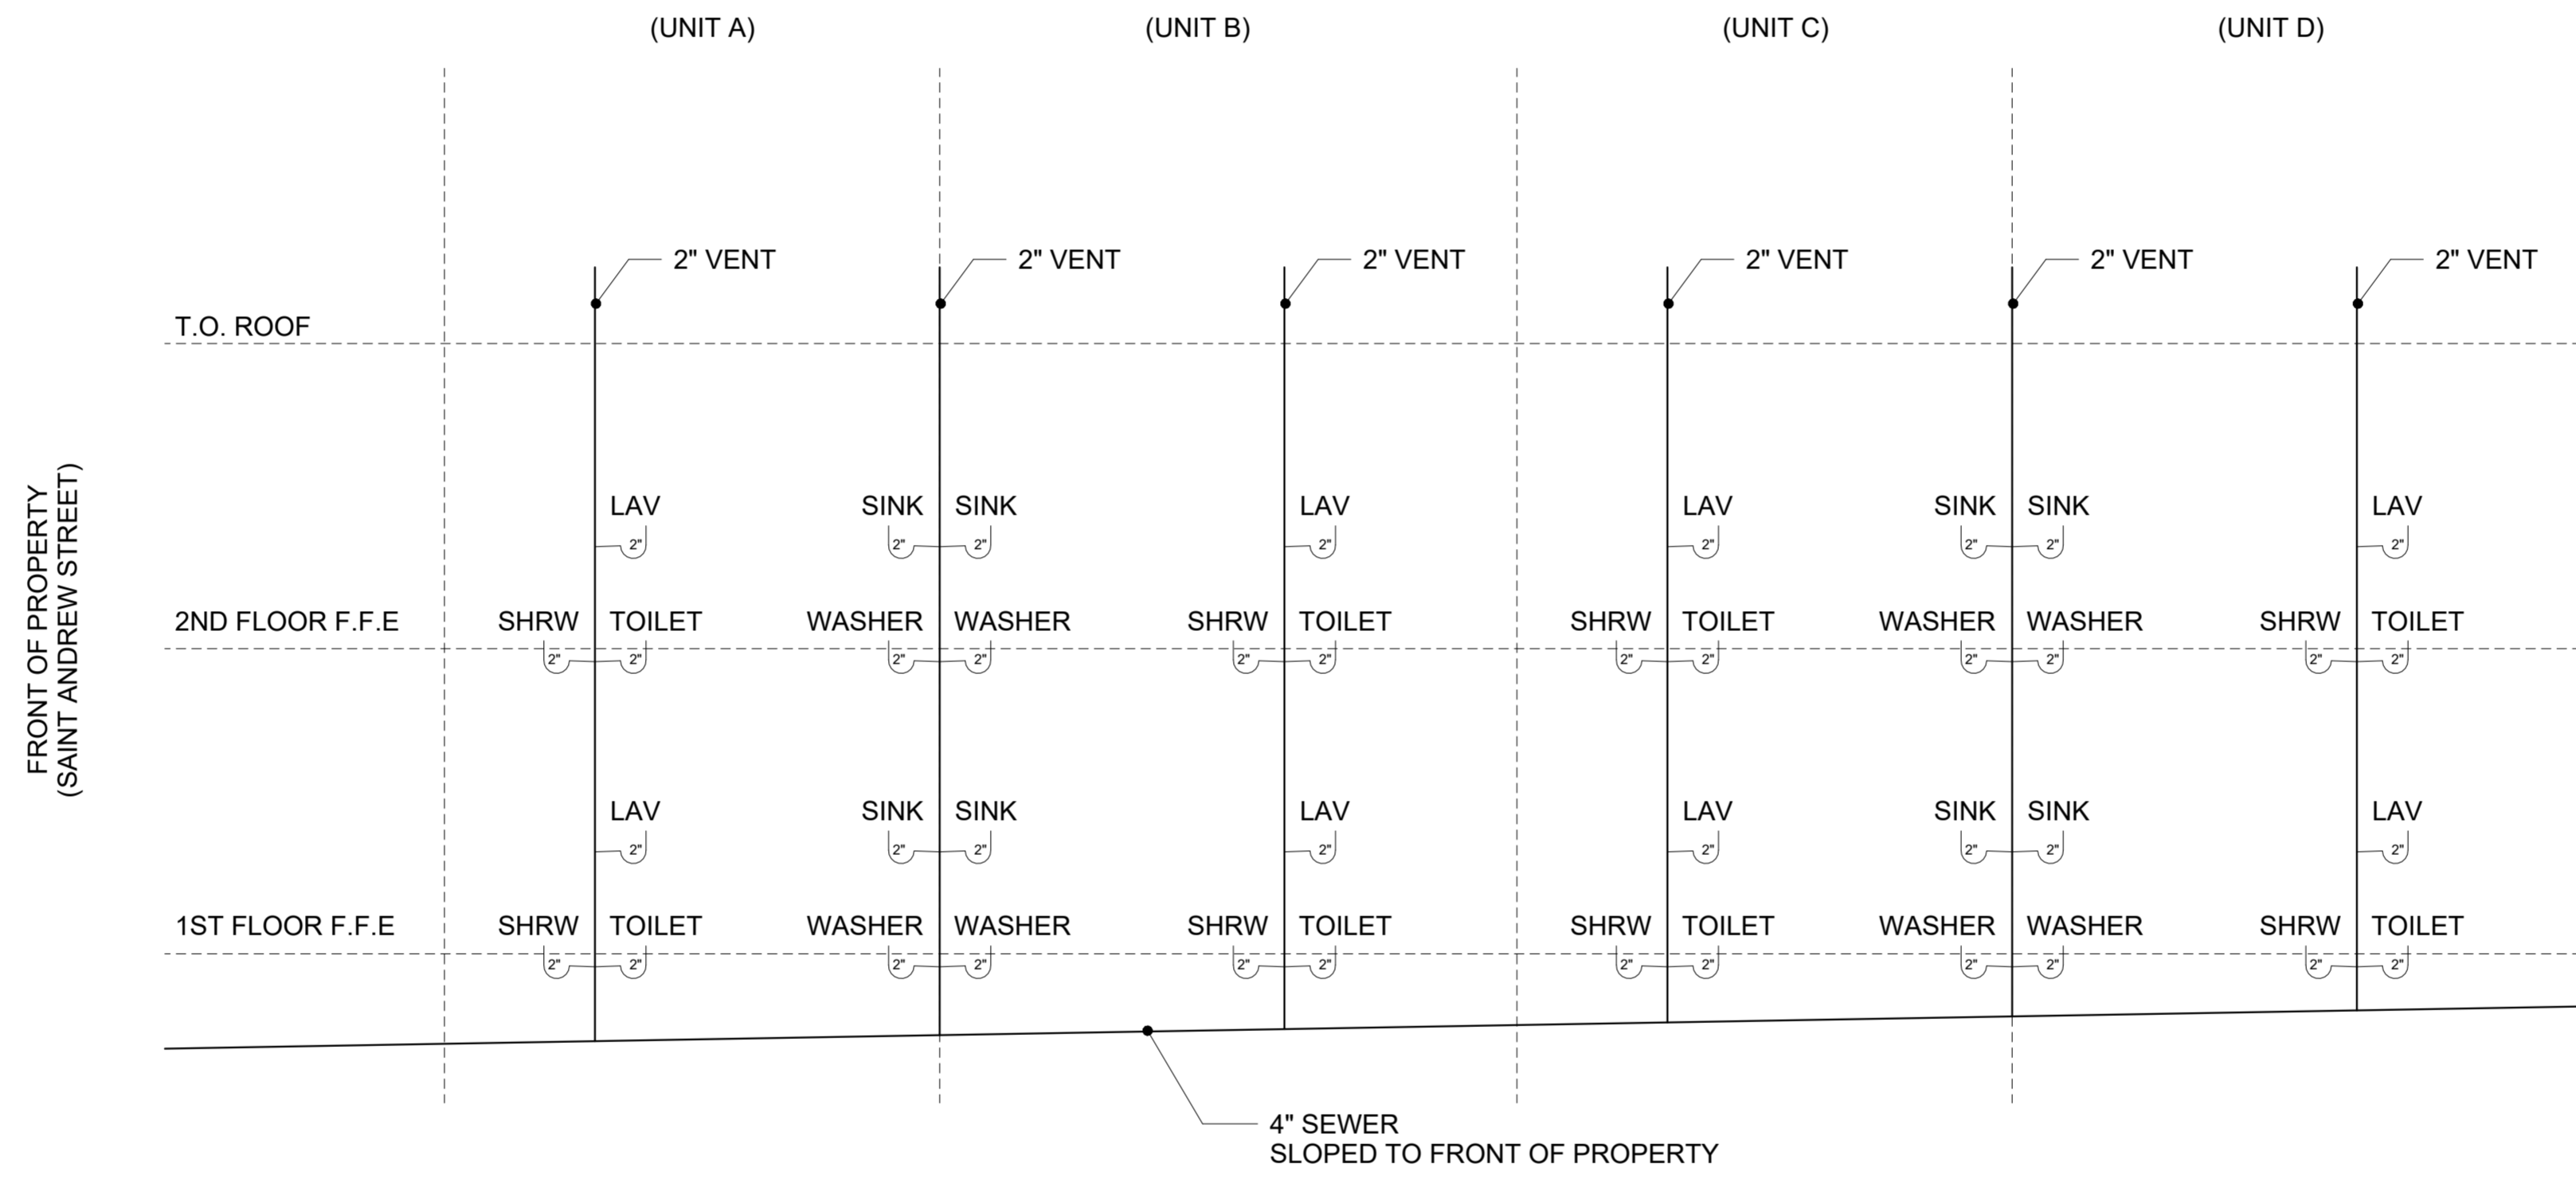


NOTE: VENT TO ATMOSPHERE

ZACH SMITH
CONSULTING & DESIGN

530 S Norman C Francis Parkway Suite 102
New Orleans, LA 70119
zach@zachsmithconsulting.com
+1 (504) 383-3748

1711 St. Andrew
New Orleans LA, 70113

No.	Description	Date
9	Plumbing Riser Diagram	08_25_22

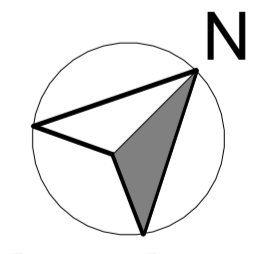

PLUMBING RISER DIAGRAM

Project name: St. Andrew Apt
 Project number: 21011
 Date: 3/31/22
 Drawn by: MG
 Checked by: Checker

A900