


APPROVED  
mreavans , 10/10/2022 7:13:28 AM

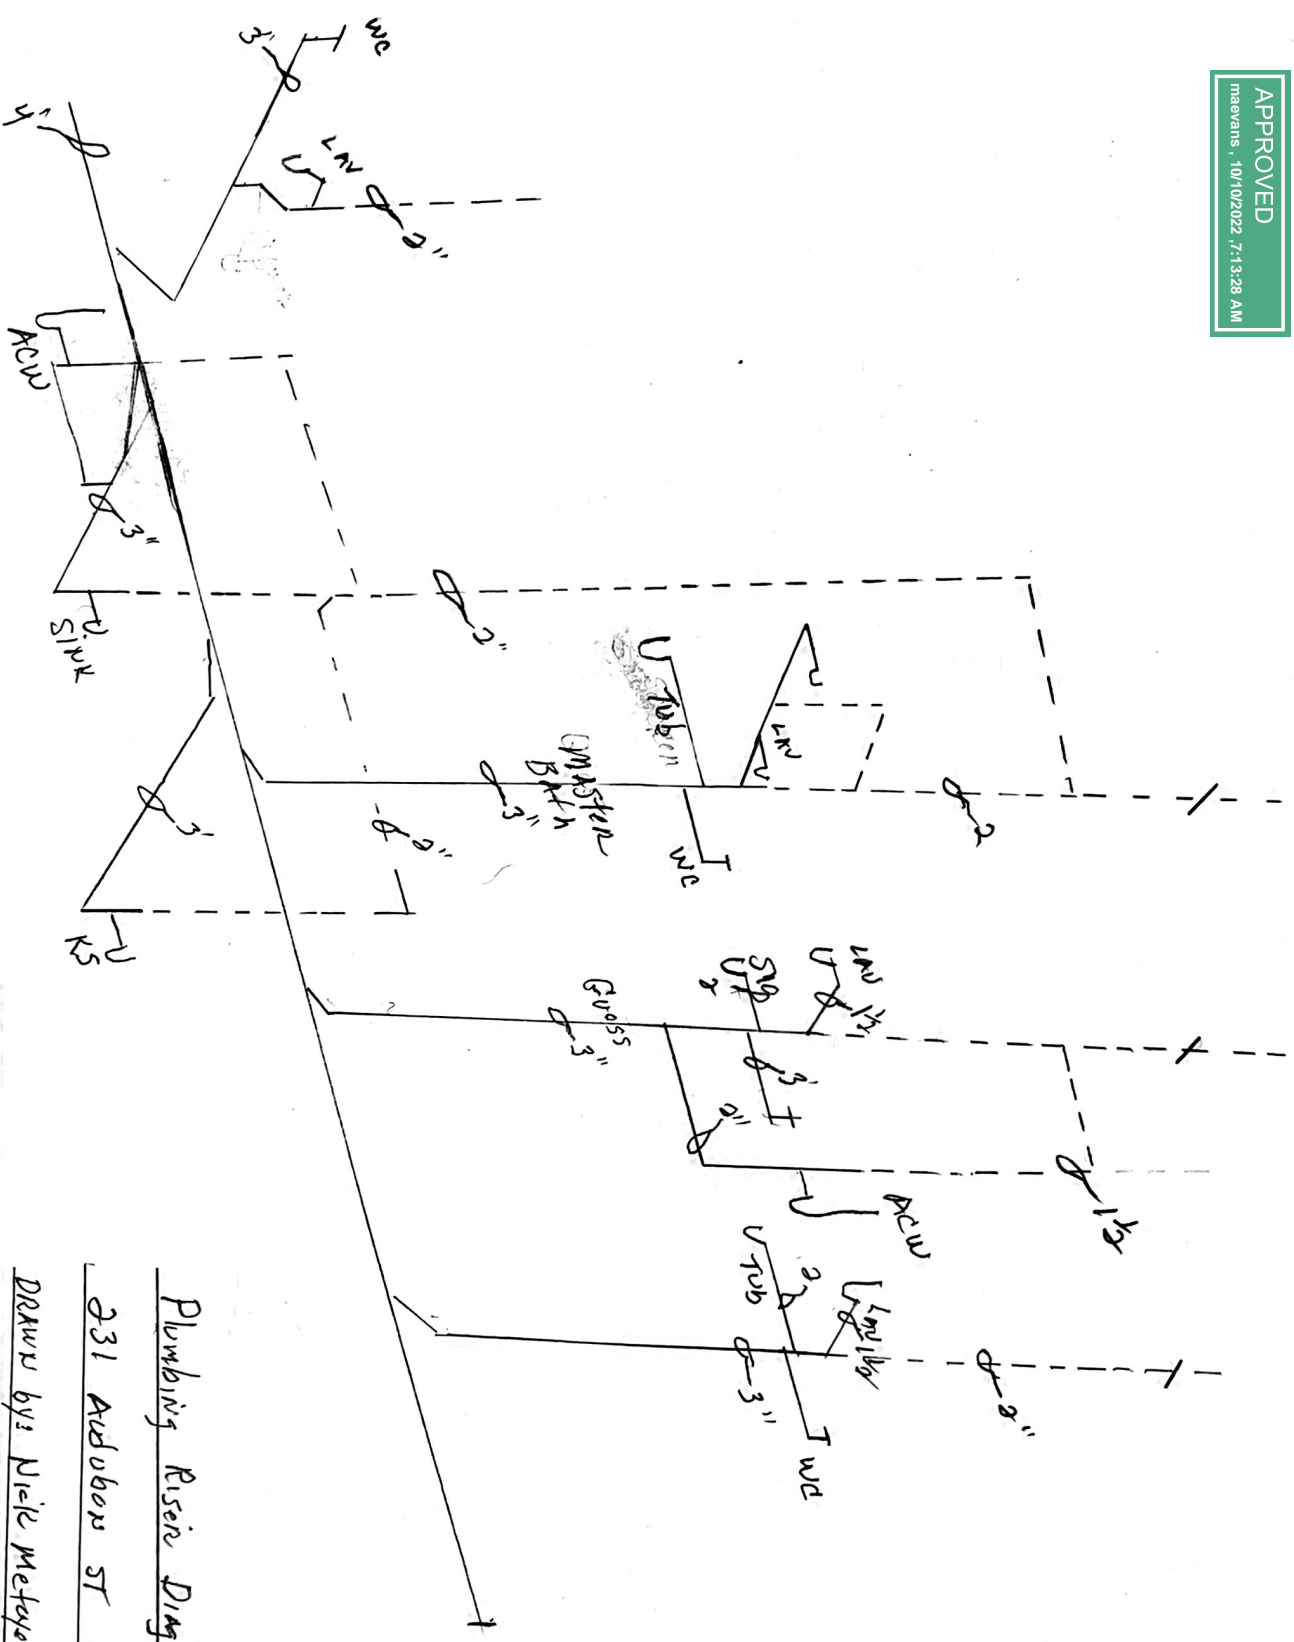

Plumbing Riser Diagram

231 Audobon ST NOLA

DRAWN BY: Nick Metzger LMP 430