



APPROVED
maevans , 11/15/2022 ,7:43:26 AM

PLUMBING RISER DIAGRAM

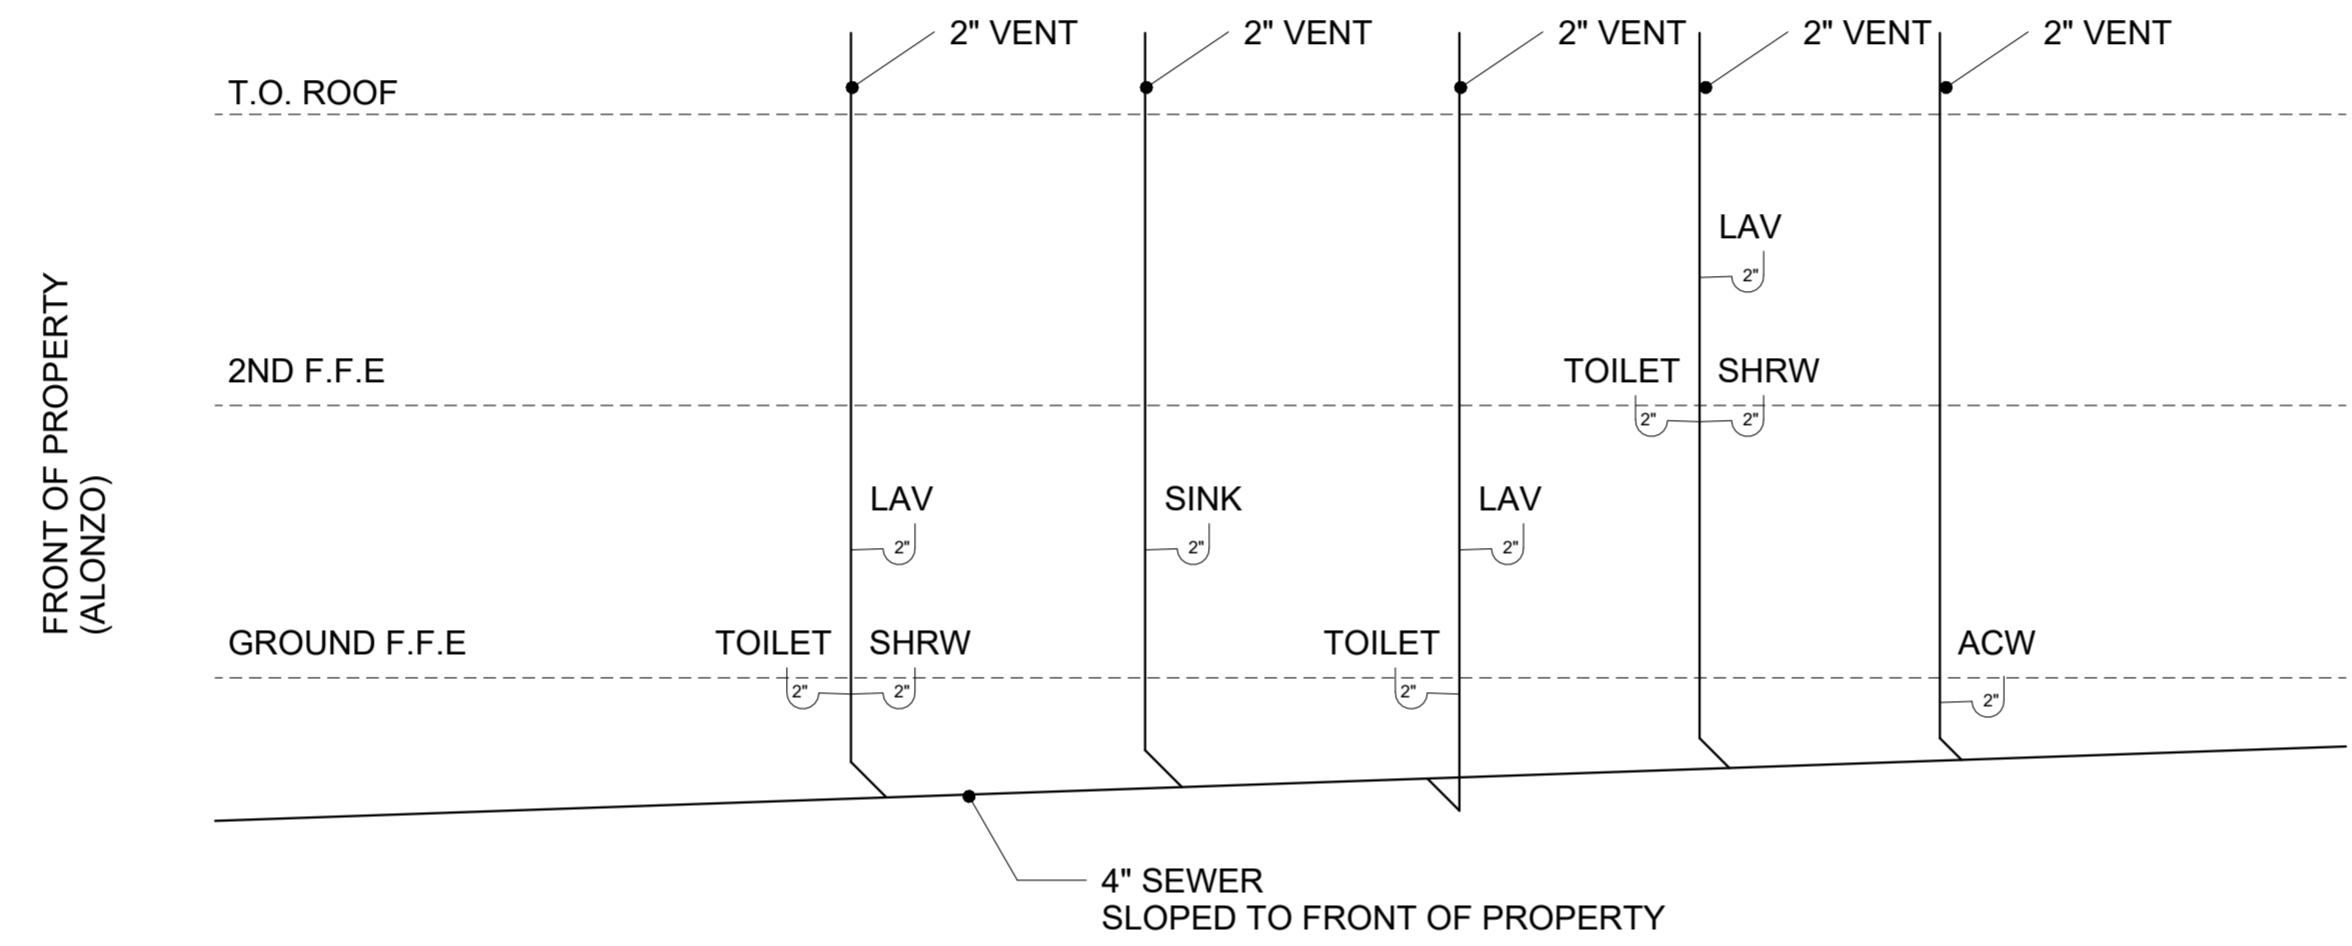


NOTE: VENT TO ATMOSPHERE

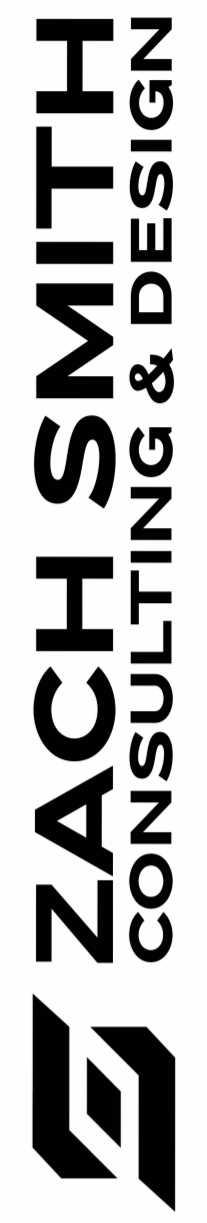

530 S Norman C Francis Parkway Suite 102
New Orleans, LA 70119
zach@zachsmithconsulting.com
+1 (504) 383-3748

211 Alonzo St
New Orleans, LA 70115

No.	Description	Date

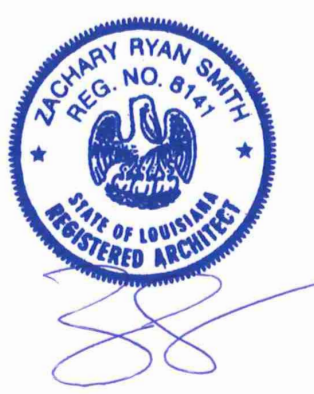

PLUMING RISER DIAGRAM
Project name 211 Alonzo St. Addition
Project number 22051
Date 09/20/2022
Drawn by MG
Checked by ZS

A900